

DESIGN DATA				
Traffic		Average Daily		
Current	2020	Pass: 1084	Trucks: 704	Total: 1788
Preventive Maintenance				



	STATE	PROJECT NO.	PCN	SECTION NO.	SHEET NO.
	ND	IM-5-094(156)023	23325	1	1

NORTH DAKOTA
DEPARTMENT OF TRANSPORTATION

IM-5-094(156)023

GOVERNING SPECIFICATIONS	Date Published and Adopted by the North Dakota Department of Transportation
Standard Specifications	1/1/2022
Supplemental Specifications	NONE

PROJECT NUMBER \ DESCRIPTION	NET MILES	GROSS MILES
IM-5-094(156)023 - EB/Mill & HMA	2.000	9.00
- WB/Mill & HMA	1.630	2.32

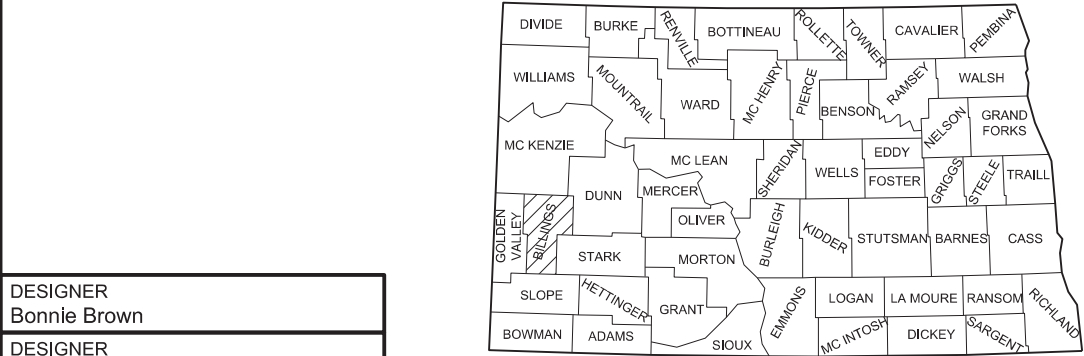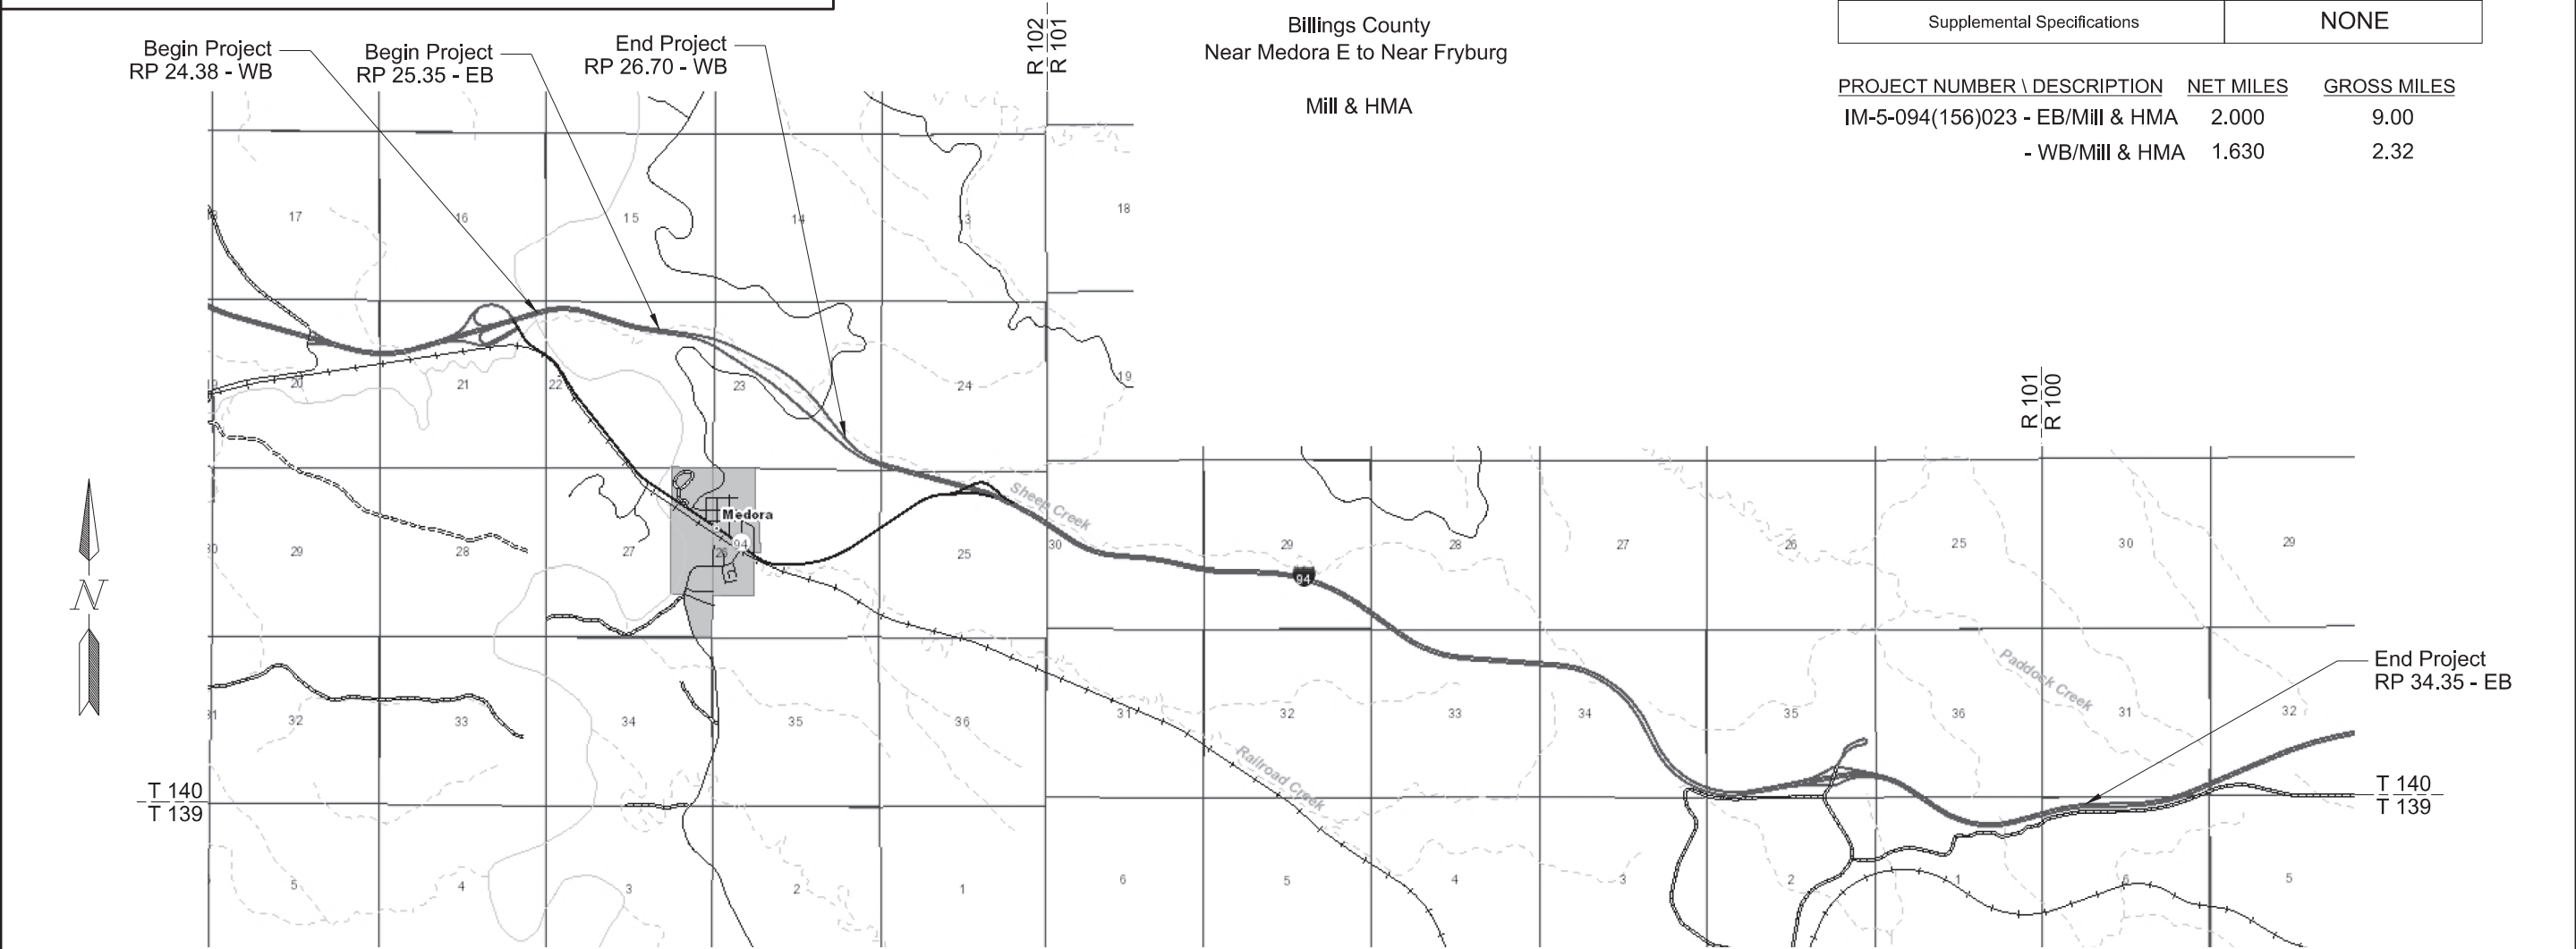

STATE COUNTY MAP

Structure #	Type	Exception
0094-025.204	RCB	no
0094-025.593	RCB	no
0094-026.204 L	Bridge	no
0094-026.204 R	Bridge	no
0094-026.217 M	RCB	no
0094-026.422 L	RCB	no
0094-027.243	Bridge	no
0094-032.963	Bridge	no

DESIGNER Bonnie Brown
DESIGNER
DESIGNER


ND DEPARTMENT OF TRANSPORTATION
DICKINSON DISTRICT
Robert R. Ruy
02 24 2022

DICKINSON DISTRICT


REGISTERED PROFESSIONAL ENGINEER
Jason R. Fischer
JASON R. FISCHER
PE-6865
DATE
02 28 2022
NORTH DAKOTA

TABLE OF CONTENTS						STATE	PROJECT NO.	SECTION NO.	SHEET NO.
						ND	IM-5-094(156)023	2	1
PLAN SECTIONS			LIST OF STANDARD DRAWINGS						
Section	Page(s)	Description	Number	Description					
1	1	Title Sheet	D-101-1, 2-4	NDDOT Abbreviations					
2	1	Table of Contents	D-101-10	NDDOT Utility Company and Organization Abbreviations					
4	1-2	Scope of Work	D-101-20, 21	Line Styles					
6	1	Notes	D-101-30, 31-33	Symbols					
8	1	Quantities	D-704-6	Construction Sign Details Project Funding Sign					
10	1	Basis of Estimate	D-704-7	Breakaway Systems For Construction Zone Signs - Perforated Tube					
30	1-3	Typical Sections	D-704-8	Breakaway Systems For Construction Zone Signs - U-Channel Post					
100	1-3	Work Zone Traffic Control	D-704-9	Construction Sign Details - Terminal And Guide Signs					
			D-704-10	Construction Sign Details - Regulatory Signs					
			D-704-11	Construction Sign Details - Warning Signs					
			D-704-13	Barricade And Channelizing Device Details					
			D-704-14	Construction Sign Punching And Mounting Details					
			D-704-22	Construction Truck And Temporary Detour Layouts					
			D-704-27	Mobile Operation (Pavement Marking)					
			D-704-35	Sign Layout For One Lane Closure - Interstate System					
			D-704-50	Portable Sign Support Assembly					
			D-706-1	Bituminous Laboratory					
			D-762-2	Interstate Pavement Marking 4 Lane Divided Highway					
			D-762-4	Pavement Marking					
			D-762-11	Short-Term Pavement Marking					
SPECIAL PROVISIONS									
Number	Description								
SSP 10	E-Ticketing								

	STATE	PROJECT NO.	SECTION NO.	SHEET NO.
	ND	IM-5-094(156)023	4	1

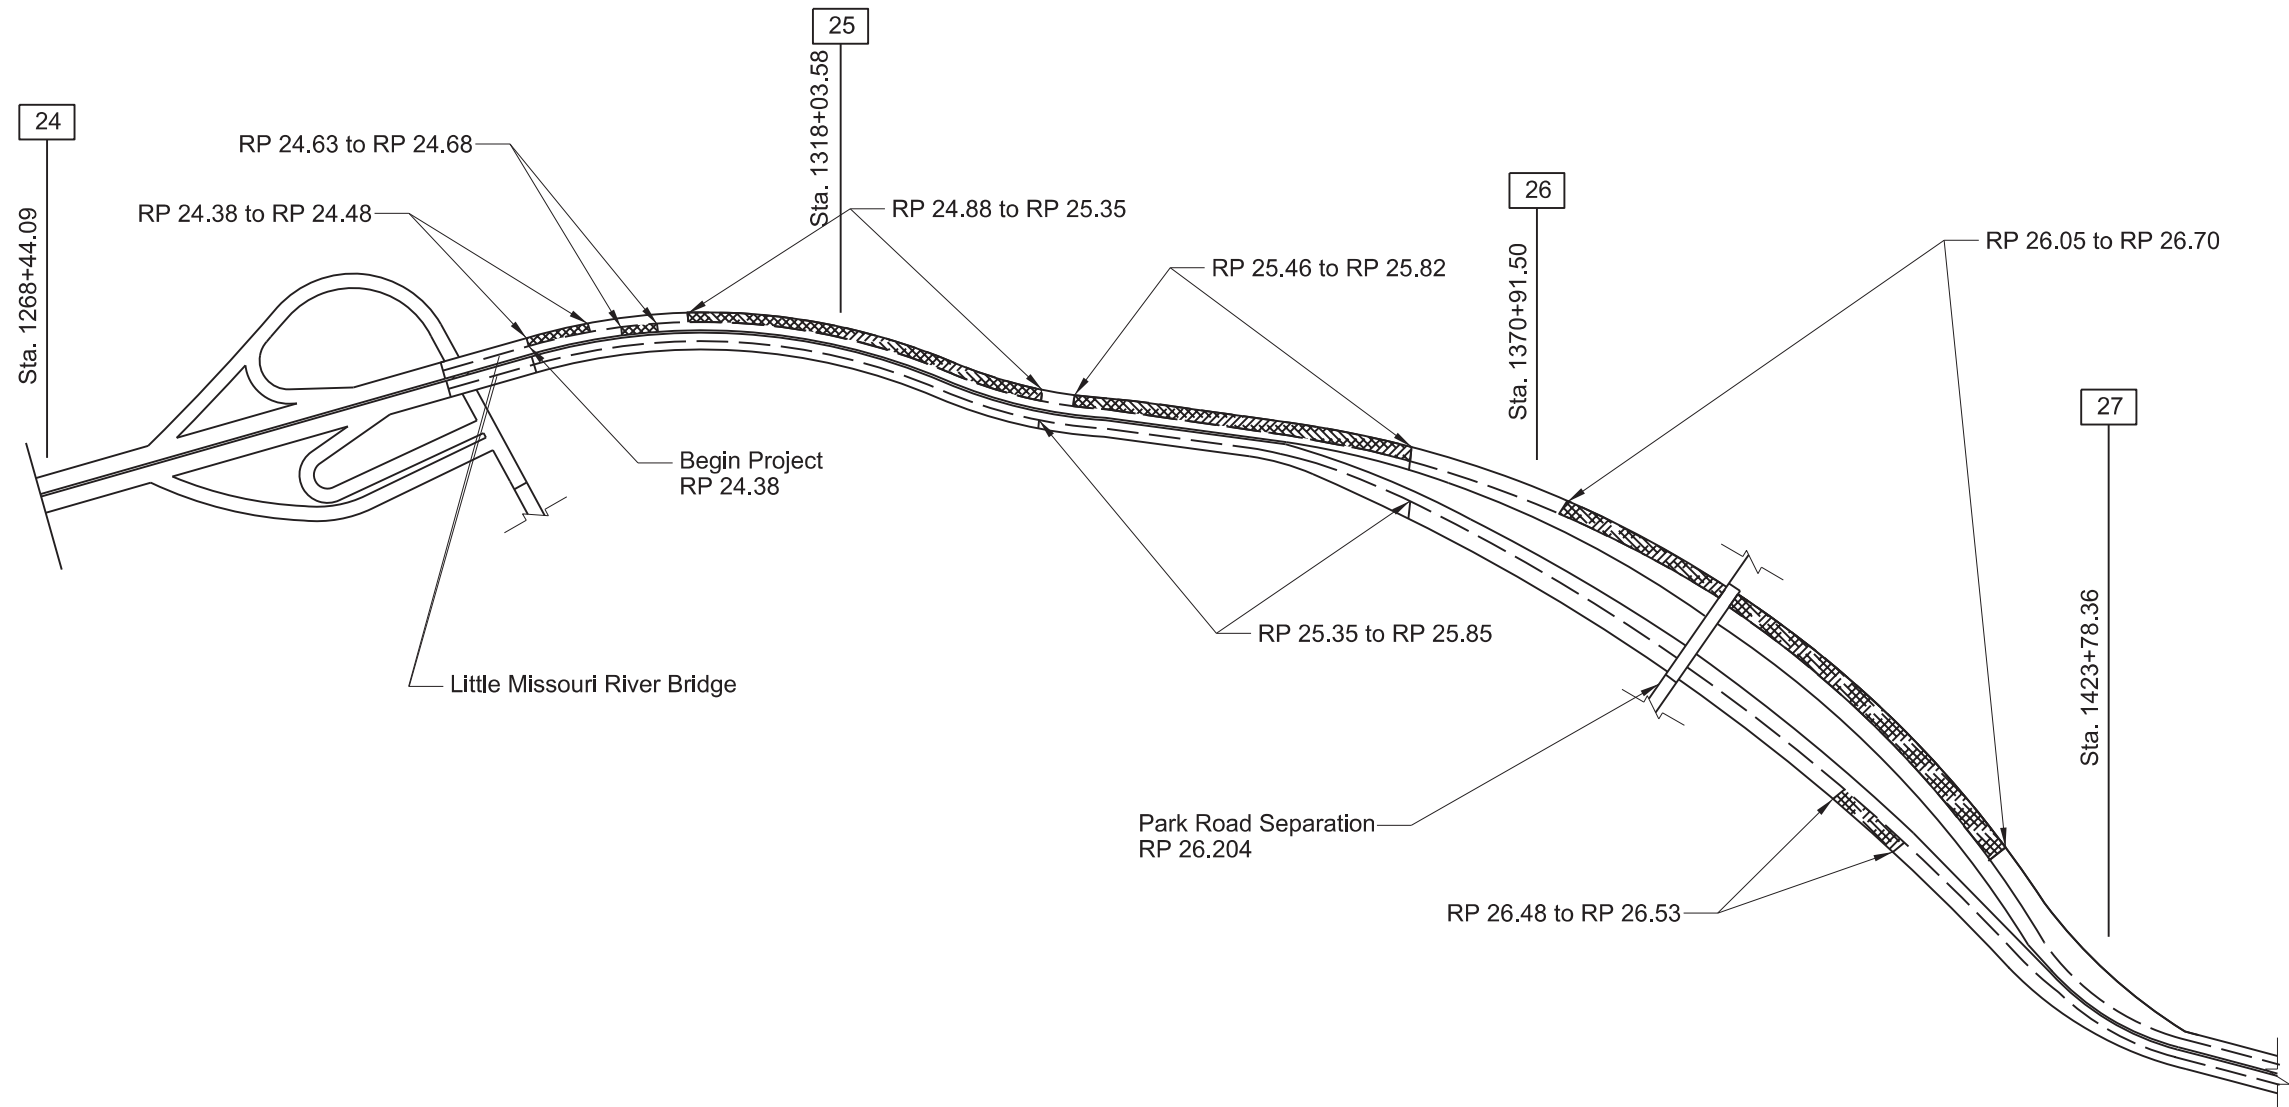



 Mill & HMA

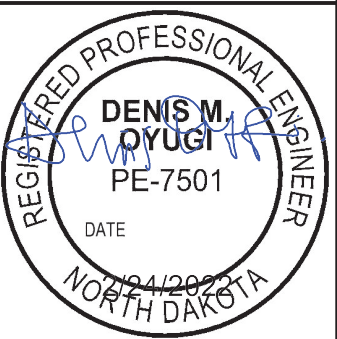

Not to Scale

Scope of Work
Mill & HMA
Near Medora E to Near Fryburg

	STATE	PROJECT NO.	SECTION NO.	SHEET NO.
	ND	IM-5-094(156)023	4	2

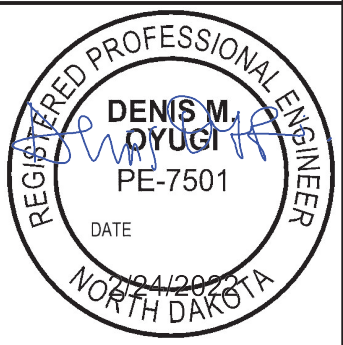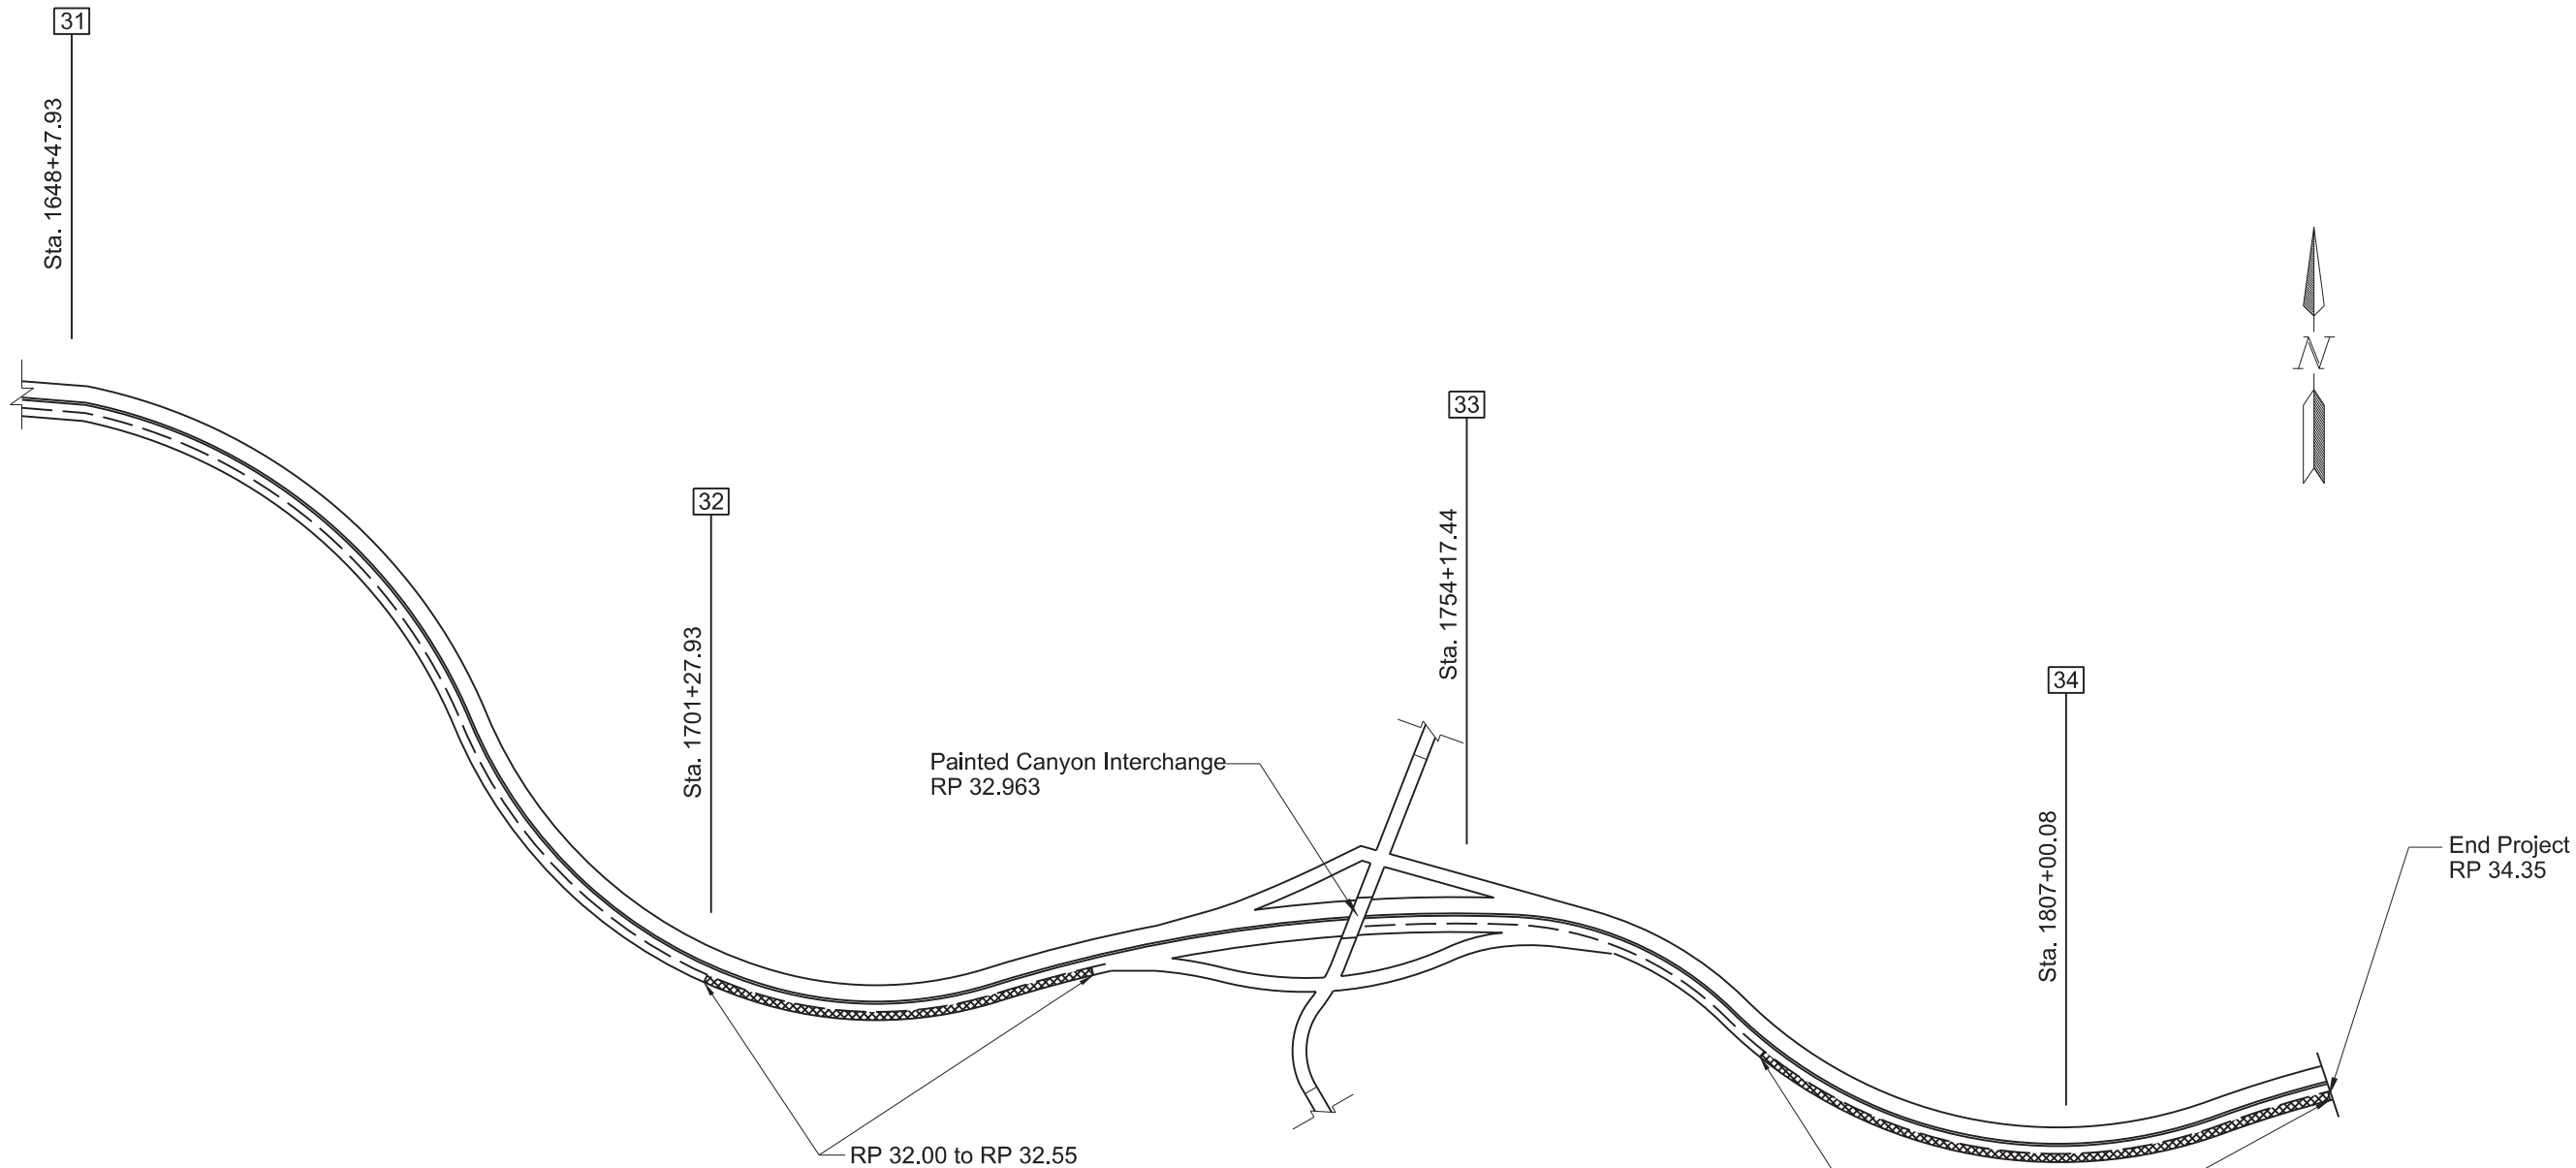


Not to Scale

Scope of Work
Mill & HMA
Near Medora E to Near Fryburg

NOTES

STATE	PROJECT NO.	SECTION NO.	SHEET NO.
ND	IM-5-094(156)023	6	1

- 100-P01 TIED PROJECTS: This project is tied to project SS-5-094(153)903. Portable traffic control devices for D-704-22 K/L used on these tied projects will be paid for once, on project SS-5-094(153)903, even though they are used on both projects.
- Contract bond, Mobilization, Contractor lab and Bituminous lab bid items will be split and paid for on each project.
- 411-P01 MILLING PAVEMENT SURFACE: Mill existing bituminous surface at the begin and end of all patching locations to create a smooth, vertical plane along the face of the surface to remain.
- 704-P01 TRAFFIC CONTROL FOR HMA OVERLAYS: Provide traffic control consisting of a temporary lane closure and flagging.
- The maximum work zone length is limited to 3 miles in each direction of travel.
- The traffic control device list is based on a two 3-mile work zones and the following list:
1. Standard D-704-22, Types K and L; for trucks entering roadway
 2. Standard D-704-26, Types CC, EE, and GG; where conditions exist
 3. Standard D-704-35; for lane closure on the interstate
- Complete work in a manner such that lane closures can safely be removed if no work is to take place for more than 3 consecutive days. Remove lane closures if no work is to take place for more than 3 consecutive days.
- The Department will pay for all necessary deployed devices within the 3-mile work zone limitation. Any additional devices will be at the Contractor's expense.
- 762-P01 SHORT TERM PAVEMENT MARKING: One application of short-term pavement marking is provided in the quantities for installation after the paving is complete.
- 762-050 PAVEMENT MARKING: If the Engineer and Contractor agree, plan quantity will be used as the measurement for payment for pavement marking items

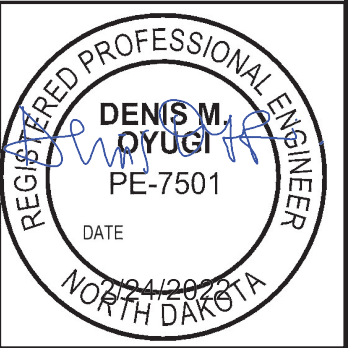

ESTIMATE OF QUANTITIES

STATE	PROJECT NO.	SECTION NO.	SHEET NO.
ND	IM-5-094(156)023	8	1

SPEC	CODE	ITEM DESCRIPTION	UNIT	MAINLINE	TOTAL
----	----	-----	----	-----	-----
103	0100	CONTRACT BOND	L SUM	0.7	0.7
401	0050	TACK COAT	GAL	1,278	1,278
411	0105	MILLING PAVEMENT SURFACE	SY	25,555	25,555
430	0045	SUPERPAVE FAA 45	TON	2,131	2,131
430	1000	CORED SAMPLE	EA	24	24
430	5818	PG 58H-34 ASPHALT CEMENT	TON	128	128
702	0100	MOBILIZATION	L SUM	0.7	0.7
704	0100	FLAGGING	MHR	128	128
704	1000	TRAFFIC CONTROL SIGNS	UNIT	2,002	2,002
704	1052	TYPE III BARRICADE	EA	12	12
704	1067	TUBULAR MARKERS	EA	220	220
704	1087	SEQUENCING ARROW PANEL-TYPE C	EA	2	2
706	0550	BITUMINOUS LABORATORY	EA	0.7	0.7
706	0600	CONTRACTOR'S LABORATORY	EA	0.7	0.7
762	0430	SHORT TERM 4IN LINE-TYPE NR	LF	4,792	4,792
762	1104	PVMT MK PAINTED 4IN LINE	LF	23,958	23,958

Design Calculations - Mainline

		RP 24.38 to RP 24.48		RP 24.63 to RP 24.68		RP 24.88 to RP 25.35		RP 25.46 to RP 25.82		RP 26.05 to RP 26.70	
		WB Driving Lane		WB Passing Lane		WB Driving Lane		WB Driving Lane		WB Driving Lane	
		Net Length = 0.10 miles		Net Length = 0.05 miles		Net Length = 0.47 miles		Net Length = 0.36 miles		Net Length = 0.65 miles	
Material	Unit	Width (ft)	Quantity	Width (ft)	Quantity	Width (ft)	Quantity	Width (ft)	Quantity	Width (ft)	Quantity
Tack Coat @ 0.05 Gal/SY	Gal	12	35.20	12	17.60	12	165.47	12	126.73	12	228.80
Superpave FAA 45 @ 2 Ton/CY*	Ton	12	58.71	12	29.35	12	275.96	12	211.36	12	381.59
PG 58H-34 Asphalt Cement @ 6%	Ton	12	3.52	12	1.76	12	16.56	12	12.68	12	22.90
Milling Pavement Surface (1-1/2" depth)	SY	12	704.00	12	352.00	12	3308.80	12	2534.40	12	4576.00

*Areas in Sect 30 sheets used for qty calculations

ESTIMATED QUANTITIES

		RP 25.35 to RP 25.85		RP 26.48 to RP 26.53		RP 32.00 to RP 32.55		RP 33.45 to RP 34.35		Grand Totals
		EB Driving Lane		EB Driving Lane		EB Driving Lane		EB Driving Lane		
		Net Length = 0.50 miles		Net Length = 0.05 miles		Net Length = 0.55 miles		Net Length = 0.90 miles		Length = 3.63
Material	Unit	Width (ft)	Quantity	Width (ft)	Quantity	Width (ft)	Quantity	Width (ft)	Quantity	Cumulative Quantity
Tack Coat @ 0.05 Gal/SY	Gal	12	176.00	12	17.60	12	193.60	12	316.80	1,278
Superpave FAA 45 @ 2 Ton/CY*	Ton	12	293.53	12	29.35	12	322.88	12	528.35	2,131
PG 58H-34 Asphalt Cement @ 6%	Ton	12	17.61	12	1.76	12	19.37	12	31.70	128
Milling Pavement Surface (1-1/2" depth)	SY	12	3520.00	12	352.00	12	3872.00	12	6336.00	25,555

*Areas in Sect 30 sheets used for qty calculations

Short Term Pavement Marking (Paint)

Location	Basis	Unit	Applications	Quantity
West Bound Centerline Skips	Measured	LF	1	2,152
East Bound Centerline Skips	Measured	LF	1	2,640

Permanent Pavement Marking (Paint)

Location	Basis	Unit	Applications	Quantity
West Bound Centerline Skips	Measured	LF	1	2,152
West Bound Edgeline	Measured	LF	1	8,606
East Bound Centerline Skips	Measured	LF	1	2,640
East Bound Edgeline	Measured	LF	1	10,560

Milling Pavement Surface @ 2 Ton/CY**

Locations	Tons
RP 24.38 to RP 24.48 WB	58.7
RP 24.63 to RP 24.68 WB	29.4
RP 24.88 to RP 25.35 WB	276.0
RP 25.46 to RP 25.82 WB	211.4
RP 26.05 to RP 26.70 WB	381.6
RP 25.35 to RP 25.85 EB	293.5
RP 26.48 to RP 26.53 EB	29.4
RP 32.00 to RP 32.55 EB	322.9
RP 33.45 to RP 34.35 EB	528.4
Total (Tons)	2,131

** Quantity for informational purposes only



Basis of Estimate




Mill & HMA

Near Medora E to Near Fryburg

HMA Cored Samples

	A	B		C	D		
Specification Section	Distance (Ft)÷1000	Lanes	Joints	Lifts	Quantity	Quantity	Unit
					(A × B × C)	(1 per mile)	
430.04 I.2.b(1), "General"	20	1	N/A	1	20	N/A	EA
SSP 4 Longitudinal Joint Density in HMA Pavements (Centerline)	N/A	N/A	N/A	N/A	N/A	N/A	EA
430.04 I.2.b(2), "Pavement Thickness Determination Cores"						4	EA
					20	4	EA

	STATE	PROJECT NO.	SECTION NO.	SHEET NO.
	ND	IM-5-094(156)023	30	1


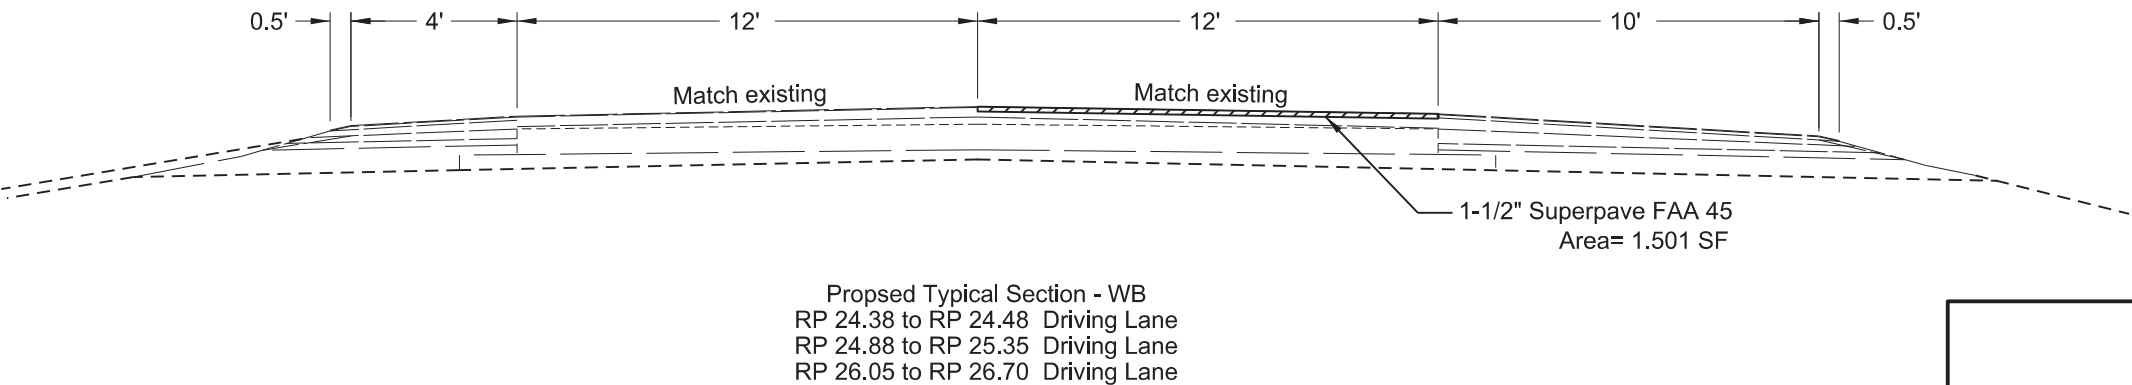
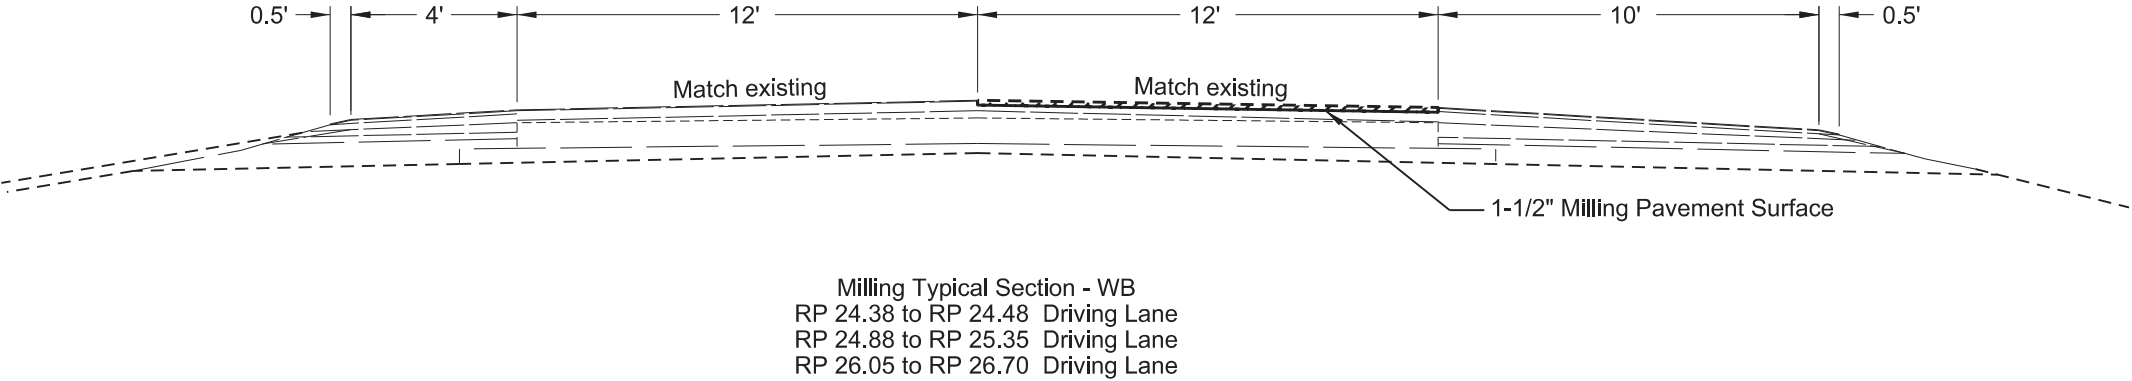
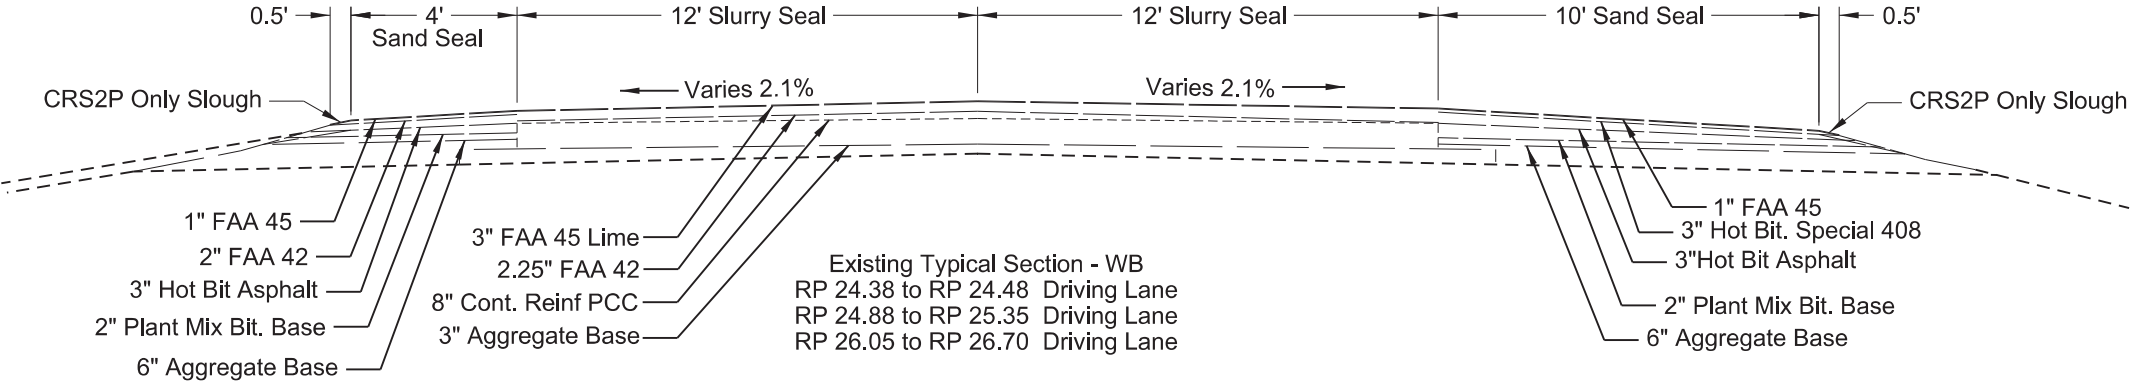


Typical Sections

Mill & HMA





Near Medora E to Near Fryburg

	STATE	PROJECT NO.	SECTION NO.	SHEET NO.
	ND	IM-5-094(156)023	30	2

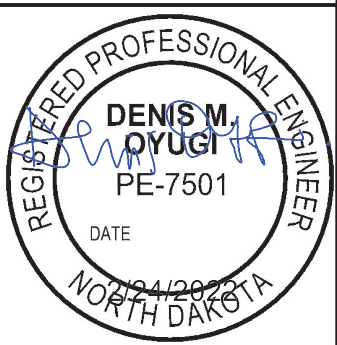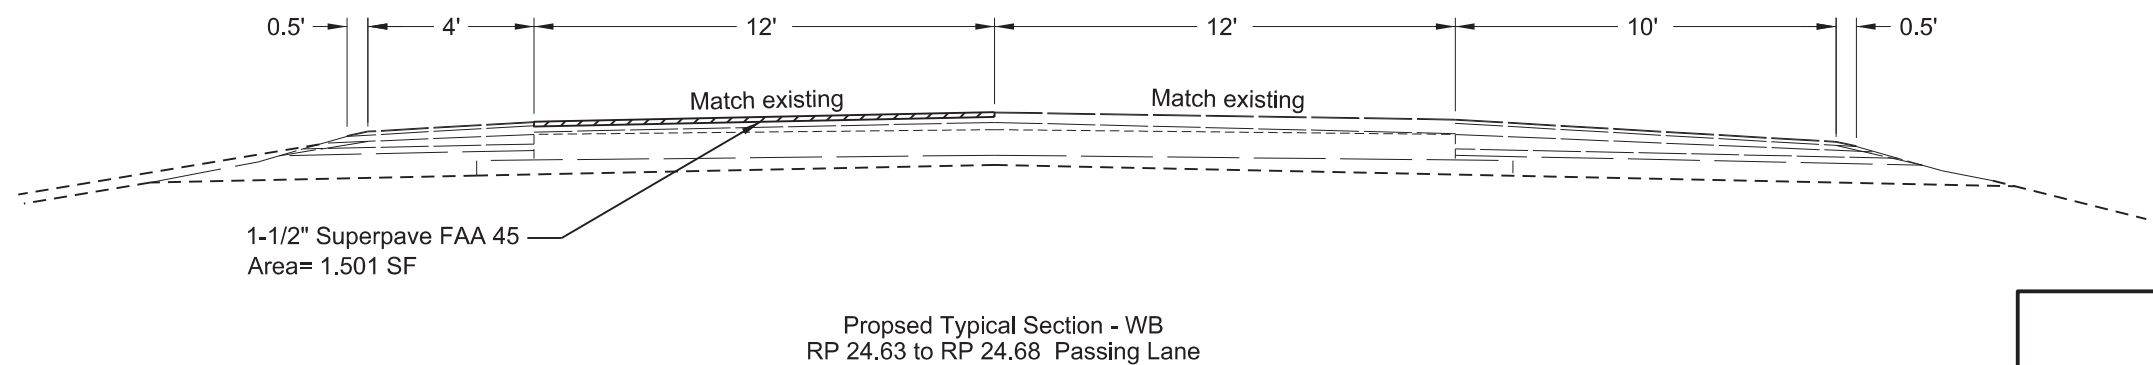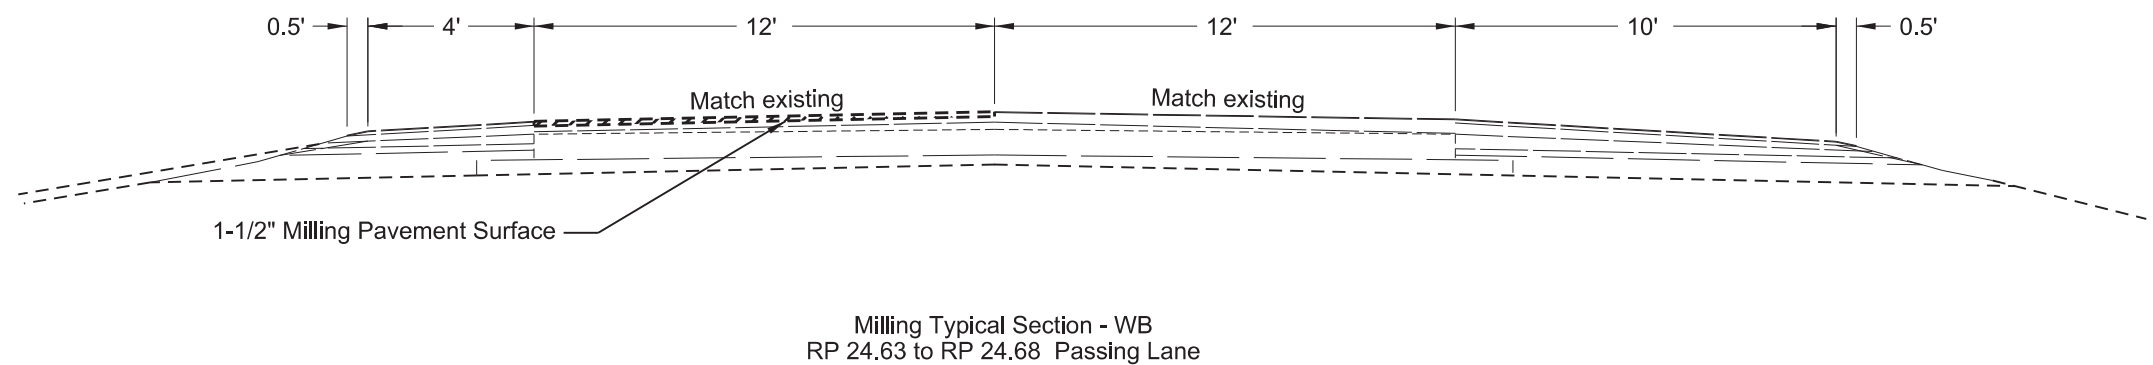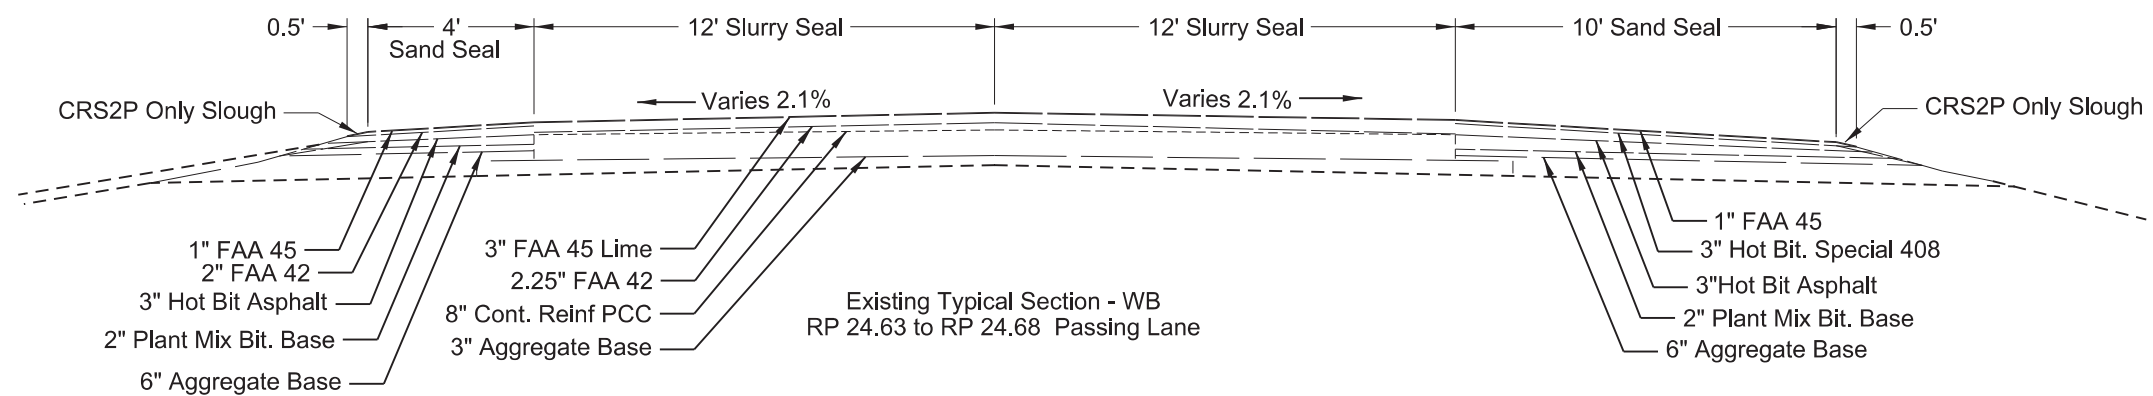

Typical Sections
Mill & Overlay
Near Medora E to Near Fryburg

	STATE	PROJECT NO.	SECTION NO.	SHEET NO.
	ND	IM-5-094(156)023	30	3

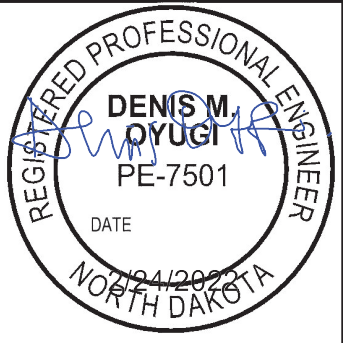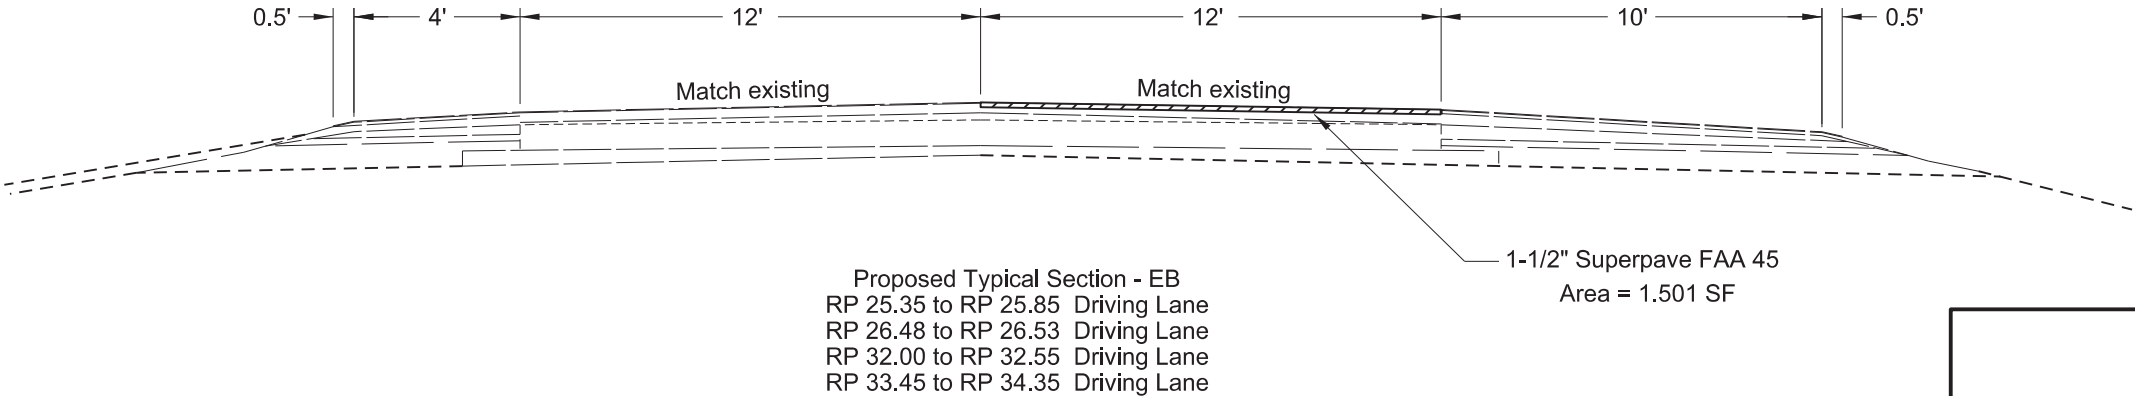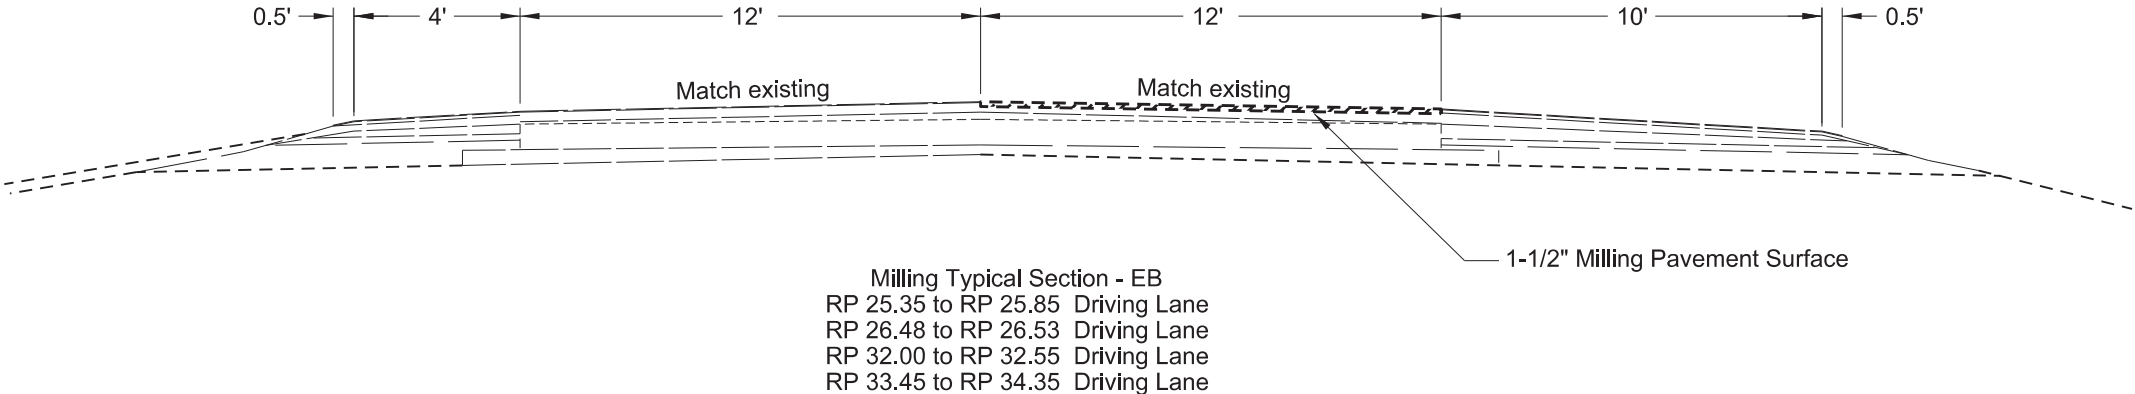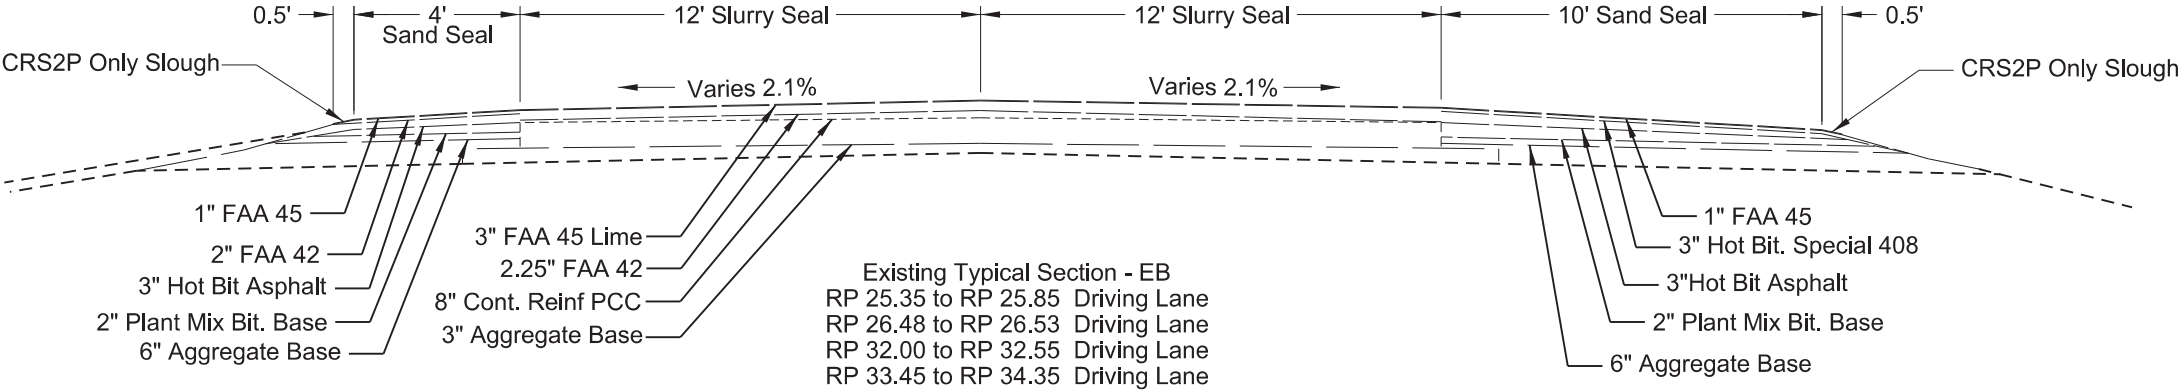

Typical Section

Mill & HMA

Near Medora E to Near Fryburg

STATE	PROJECT NO.	SECTION NO.	SHEET NO.
ND	IM-5-094(156)023	100	1

SIGN NUMBER	SIGN SIZE	DESCRIPTION	AMOUNT REQUIRED	UNITS PER AMOUNT	UNITS SUB TOTAL
E5-1-48	48"x48"	EXIT GORE	1	35	35
G20-1-60	60"x24"	ROAD WORK NEXT ___ MILES	4	28	112
G20-1b-60	60"x24"	NO WORK IN PROGRESS (Sign and installation only)		18	
G20-2-48	48"x24"	END ROAD WORK	5	26	130
G20-4-36	36"x18"	PILOT CAR FOLLOW ME (Mounted to back of pilot car)		18	
G20-10-108	108"x48"	CONTRACTOR SIGN		70	
G20-50a-72	72"x36"	ROAD WORK NEXT ___ MILES RT & LT ARROWS		43	
G20-52a-72	72"x24"	ROAD WORK NEXT ___ MILES RT or LT ARROW		36	
G20-55-96	96"x48"	SPEED LIMIT ENFORCED - MINIMUM FEE \$80 WHEN WORKERS PRESENT	4	59	236
I2-5-96	96"x48"	YOUR HIGHWAY DOLLARS AT WORK	4	59	236
M1-1-36	36"x36"	INTERSTATE ROUTE MARKER (Post and installation only)		10	
M1-4-24	24"x24"	U.S. ROUTE MARKER (Post and installation only)		10	
M1-5-24	24"x24"	STATE ROUTE MARKER (Post and installation only)		10	
M3-1-24	24"x12"	NORTH (Mounted on route marker post)		7	
M3-2-24	24"x12"	EAST (Mounted on route marker post)		7	
M3-3-24	24"x12"	SOUTH (Mounted on route marker post)		7	
M3-4-24	24"x12"	WEST (Mounted on route marker post)		7	
M4-8-24	24"x12"	DETOUR (Mounted on route marker post)		7	
M4-9-30	30"x24"	DETOUR ARROW RIGHT or LEFT/AHD AND RT or LT		15	
M4-10-48	48"x18"	DETOUR (INSIDE ARROW) RIGHT or LEFT (Mounted on barricade)		7	
M5-1-21	21"x15"	ADVANCE TURN ARROW RT or LT(Mounted on route marker post)		7	
M5-1-30	30"x21"	ADVANCE TURN ARROW RT or LT(Mounted on route marker post)		9	
M6-1-21	21"x15"	DIRECTIONAL ARROW RT or LT (Mounted on route marker post)		7	
M6-1-30	30"x21"	DIRECTIONAL ARROW RT or LT (Mounted on route marker post)		9	
M6-3-21	21"x15"	DIRECTIONAL ARROW UP (Mounted on route marker post)		7	
R1-1-48	48"x48"	STOP	1	32	32
R1-2-60	60"x60"	YIELD	1	29	29
R2-1-36	36"x48"	SPEED LIMIT ___ (Portable only)	5	30	150
R2-1-48	48"x60"	SPEED LIMIT ___	8	39	312
R2-1aP-24	24"x18"	MINIMUM FEE \$80 (Mounted on Speed Limit post)	9	10	90
R3-2-48	48"x48"	NO LEFT TURN		35	
R4-1-48	48"x60"	DO NOT PASS		39	
R4-7-48	48"x60"	KEEP RIGHT		39	
R5-1-48	48"x48"	DO NOT ENTER		35	
R6-1-54	54"x18"	ONE WAY RIGHT or LEFT (Mounted on STOP or DO NOT ENTER post)		14	
R7-1-12	12"x18"	NO PARKING ANY TIME		11	
R10-6-24	24"x36"	STOP HERE ON RED		16	
R11-2-48	48"x30"	ROAD CLOSED (Mounted on barricade)		12	
R11-2a-48	48"x30"	STREET CLOSED (Mounted on barricade)		12	
R11-3a-60	60"x30"	ROAD CLOSED ___ MILES AHEAD LOCAL TRAFFIC ONLY (Mtd on barricade)		15	
R11-3c-60	60"x30"	STREET CLOSED ___ MILES AHEAD LOCAL TRAFFIC ONLY (Mtd on barricade)		15	
R11-4a-60	60"x30"	STREET CLOSED TO THRU TRAFFIC (Mounted on barricade)		15	
W1-3-48	48"x48"	REVERSE TURN RIGHT or LEFT		35	
W1-4-48	48"x48"	REVERSE CURVE RIGHT or LEFT		35	
W1-4b-48	48"x48"	TWO LANE REVERSE CURVE RIGHT or LEFT		35	
W1-6-48	48"x24"	ONE DIRECTION LARGE ARROW		26	
W3-1-48	48"x48"	STOP AHEAD		35	
W3-3-48	48"x48"	SIGNAL AHEAD		35	
W3-4-48	48"x48"	BE PREPARED TO STOP		35	
W3-5-48	48"x48"	SPEED REDUCTION AHEAD	4	35	140
W4-2-48	48"x48"	LANE ENDS RIGHT or LEFT	4	35	140
W5-1-48	48"x48"	ROAD NARROWS		35	
W5-8-48	48"x48"	THRU TRAFFIC RIGHT LANE		35	
W5-9-48	48"x48"	ROAD WORK TRAFFIC ONLY DOWN & LT or RT ARROW		35	
W6-3-48	48"x48"	TWO WAY TRAFFIC		35	
W8-1-48	48"x48"	BUMP		35	
W8-3-48	48"x48"	PAVEMENT ENDS		35	
W8-7-48	48"x48"	LOOSE GRAVEL		35	
W8-11-48	48"x48"	UNEVEN LANES		35	
W8-12-48	48"x48"	NO CENTER LINE		35	
W8-17-48	48"x48"	SHOULDER DROP-OFF SYMBOL		35	
W8-53-48	48"x48"	TRUCKS ENTERING HIGHWAY		35	
W8-54-48	48"x48"	TRUCKS ENTERING AHEAD or ___ FT or ___ MILE		35	
W8-55-48	48"x48"	TRUCKS CROSSING AHEAD or ___ FT or ___ MILE		35	
W8-56-48	48"x48"	TRUCKS EXITING HIGHWAY		35	
W9-3a-48	48"x48"	CENTER LANE CLOSED SYMBOL		35	
W13-1P-30	30"x30"	___ MPH ADVISORY SPEED PLAQUE (Mounted on warning sign post)		14	
W14-3-64	64"x48"	NO PASSING ZONE		28	
W16-2P-30	30"x24"	___ FEET PLAQUE (Mounted on warning sign post)		10	
W20-1-48	48"x48"	ROAD WORK AHEAD or ___ FT or ___ MILE	2	35	70
W20-2-48	48"x48"	DETOUR AHEAD or ___ FT or ___ MILE		35	
W20-3-48	48"x48"	ROAD or STREET CLOSED AHEAD or ___ FT or ___ MILE		35	
W20-4-48	48"x48"	ONE LANE ROAD AHEAD or ___ FT or ___ MILE		35	
W20-5-48	48"x48"	RIGHT or CENTER or LEFT LANE CLOSED AHEAD or ___ FT or ___ MILE	4	35	140
W20-7-48	48"x48"	FLAGGER	2	35	70
W20-8-18	18"x18"	STOP - SLOW PADDLE Back to Back	2	5	10
W20-52P-54	54"x12"	NEXT ___ MILES (Mounted on warning sign post)		12	
W21-1-48	48"x48"	WORKERS		35	
W21-2-48	48"x48"	FRESH OIL		35	
W21-3-48	48"x48"	ROAD MACHINERY AHEAD or ___ FT or ___ MILE		35	
W21-5-48	48"x48"	SHOULDER WORK		35	
W21-5a-48	48"x48"	RIGHT or LEFT SHOULDER CLOSED		35	

[illegible][illegible]

SPEC & CODE			
704-1000	TRAFFIC CONTROL SIGNS	TOTAL UNITS	2002

[illegible]


NOTE:
If additional signs are required, units will be calculated using the formula from Section III-18.06 of the Design Manual.
<http://www.dot.nd.gov/>




Traffic Control Devices List

Mill & HMA
Near Medora E to Near Fryburg

	STATE	PROJECT NO.	SECTION NO.	SHEET NO.
	ND	IM -5-094(156)023	100	2

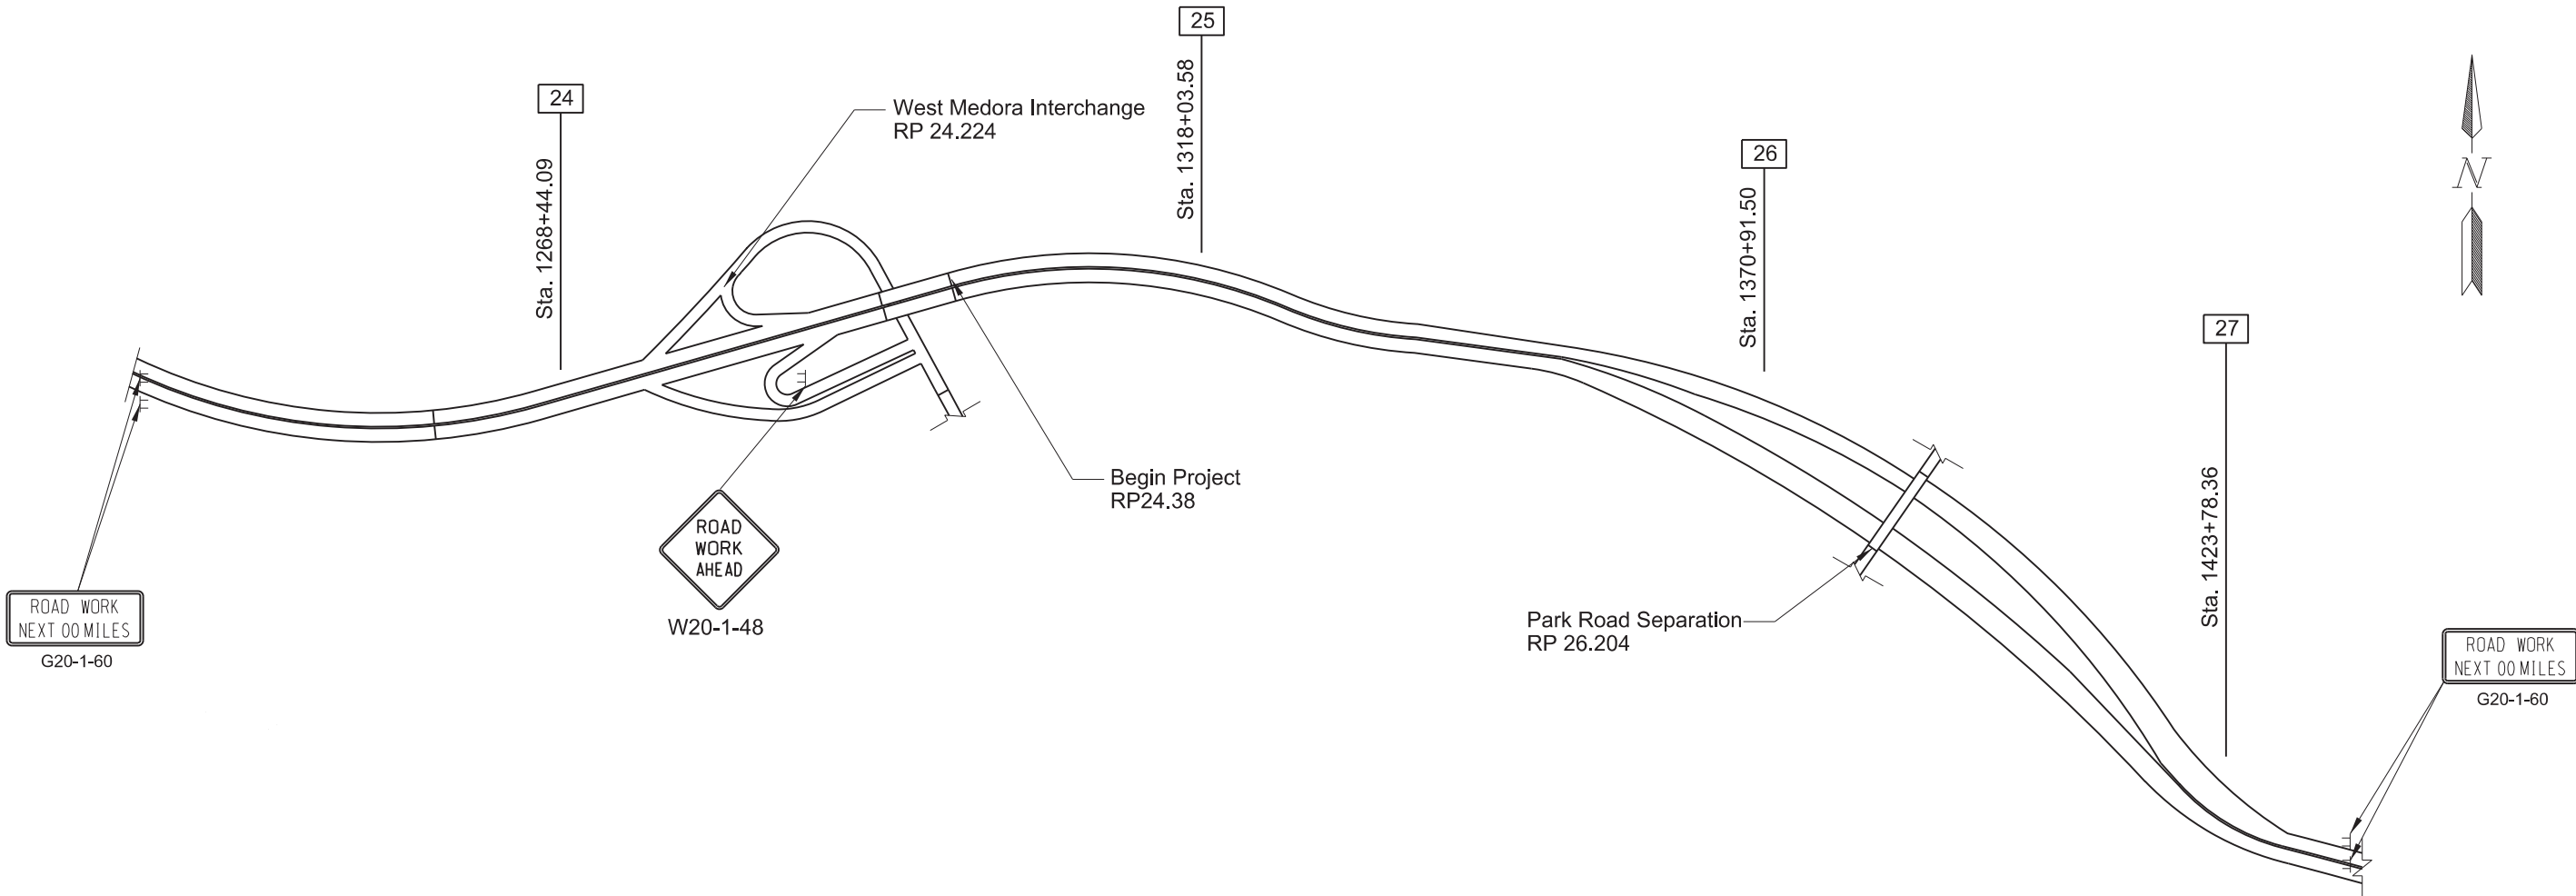


Note:
Use Standard D-704-35 for Layout & Spacing. Use G20-1-60 in place of W20-1-48

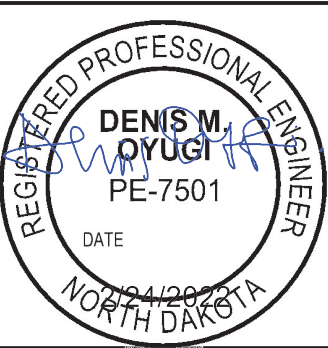

NOT TO SCALE

Construction Sign Layout
Mill & HMA
Near Medora E to Near Fryburg

	STATE	PROJECT NO.	SECTION NO.	SHEET NO.
	ND	IM-5-094(156)023	100	3

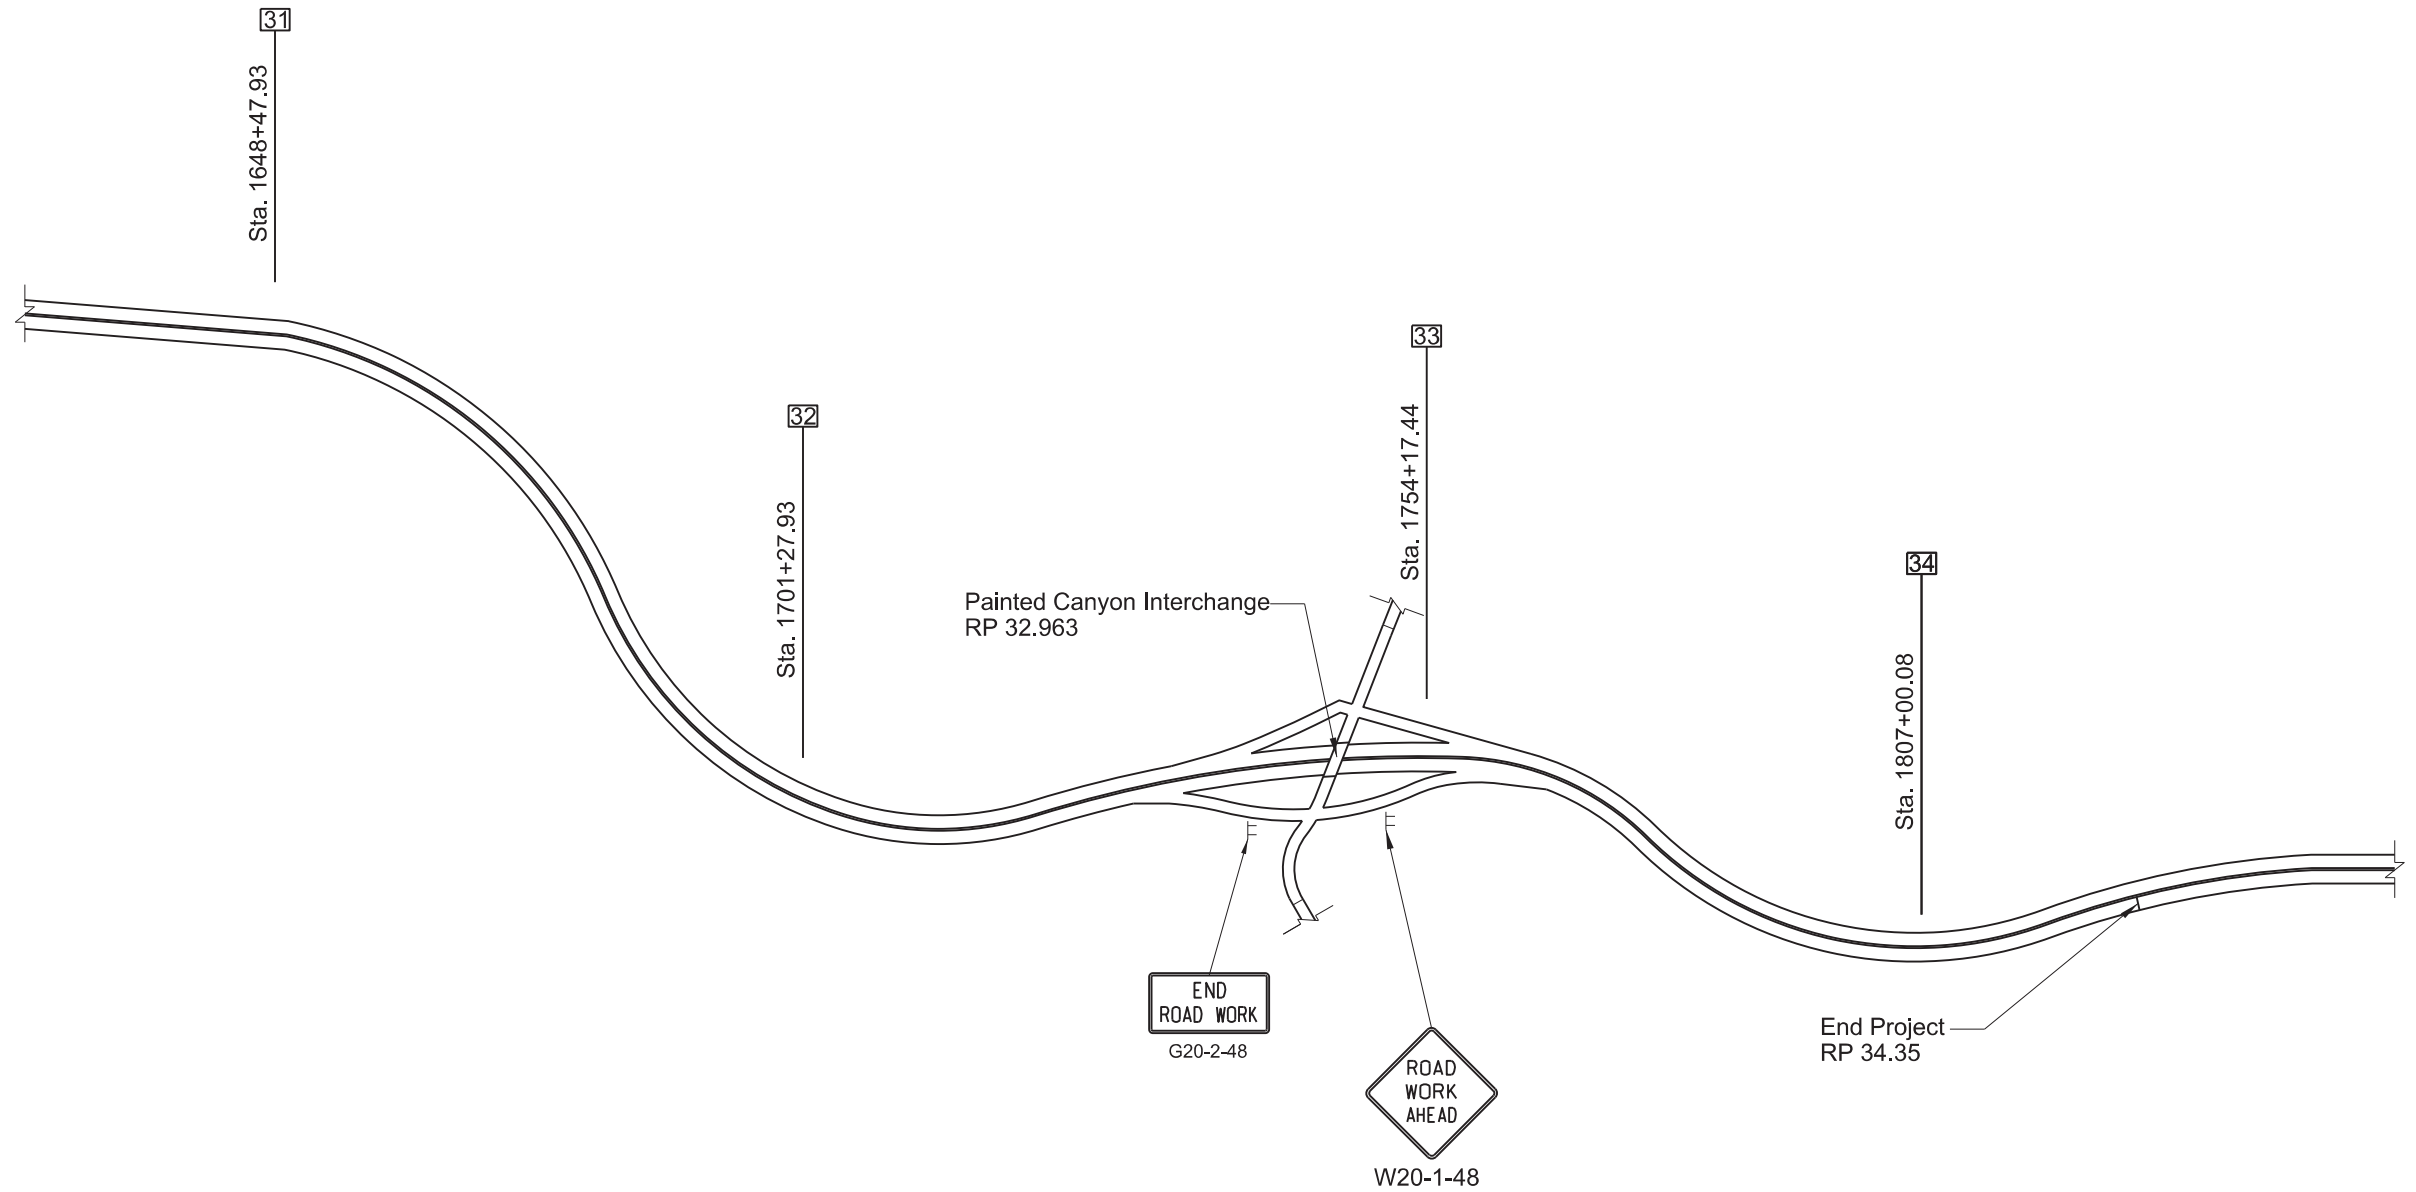

NOT TO SCALE

Construction Sign Layout

Mill & HMA

Near Medora E to Near Fryburg

Note:
Use Standard D-704-35 for Layout & Spacing. Use G20-1-60 in place of W20-1-48

NDDOT ABBREVIATIONS

D-101-1

?	This is a special text character used in the labeling of existing features. It indicates a feature that has an unknown characteristic, potentially based on: lack of description, location accuracy or purpose.	C Gdrl	cable guardrail	Culv	culvert	FOS	factor of safety
Abn	abandoned	Calc	calculate	C&G	curb & gutter	Fed	Federal
Abut	abutment	CIP	cast iron pipe	CI	curb inlet	FP	feed point
Adj	adjusted	CB	catch basin	CR	curb ramp	Fn	fence
Aggr	aggregate	CRS	cationic rapid setting	C	cut	Fn P	fence post
Ahd	ahead	C Gd	cattle guard	Dd Ld	dead load	FO	fiber optic
ARV	air release valve	C To C	center to center	Defl	deflection	FD	field drive
Align	alignment	CL or C	centerline	Defm	deformed	F	fill
Al	alley	Ch	chain	DInt	delineate	FAA	fine aggregate angularity
Alt	alternate	Ch Blk	chain-link	DIntr	delineator	FH	fire hydrant
Alum	aluminum	Ch Ch	channel block	Depr	depression	Fl	flange
ADA	Americans with Disabilities Act	Chk	channel change	Desc	description	FIRD	flared
&	and	Chsld	check	Det	detail	FES	flared end section
Appr	approach	Cir	chiseled	DWP	detectable warning panel	F Bcn	flashing beacon
Approx	approximate	Cl	circle	Dtr	detour	FA	flight auger sample
ACP	asbestos cement pipe	Clnt	class	Dia or \varnothing	diameter	FL	flow line
Asph	asphalt	Clr	clean-out	Dir	direction	Ftg	footing
AC	asphalt cement	Cl&gr	clear	Dist	distance	FM	force main
Assmd	assumed	Comb.	clearing & grubbing	DM	disturbed material	Fnd	found
@	at	Coml	combination	DB	ditch block	Fdn	foundation
Atten	attenuation	Compr	commercial	DG	ditch grade	Frac	fractional
ATR	automatic traffic recorder	CADD	compression	Dbl	double	Frwy	freeway
Ave	Avenue	Conc	computer aided drafting & design	Dn	down	Frt	front
Avg	average	CECB	concrete	Dwg	drawing	FF	front face
ADT	average daily traffic	Cond	concrete erosion control blanket	Dr	drive	F Disp	fuel dispenser
		Const	conductor	Drwy	driveway	FFP	fuel filler pipes
		Cont	construction	DI	drop inlet	FLS	fuel leak sensor
		CSB	continuous	D	dry density	Furn	furnish/ed
		Contr	continuous split barrel sample	DSDS	dynamic speed display sign		
		Contr	contraction				
		CP	contractor				
Bk	back	Coord	control point	Ea	each		
BF	back face	Cor	coordinate	Esmt	easement		
Balc	balcony	Corr	corner	E	East		
B Wire	barbed wire	CAES	corrected	EB	Eastbound		
Barr	barricade	CAP	corrugated aluminum end section	Elast	elastomeric		
Btry	battery	CMES	corrugated aluminum pipe	EL	electric locker		
BI	beehive inlet	CMP	corrugated metal end section	E Mtr	electric meter		
Beg	begin	CPVCP	corrugated metal pipe	Elec	electric/al		
BG	below grade	CSES	corrugated poly-vinyl chloride pipe	EDM	electric/al		
BM	bench mark	CSFES	corrugated steel end section	Elev or El	electronic distance meter		
Bkwy	bikeway	CSP	corrugated steel flared end section	Ellipt	elevation		
Bit	bituminous	CSTES	corrugated steel pipe	Emb	elliptical		
Blk	block	Co	corrugated steel traversable end section	Emuls	embankment		
BH	bore hole	Crse	County	ES	emulsion/emulsified		
Bot	bottom	Ct	course	Engr	end section		
Blvd	Boulevard	Xarm	Court	ESS	engineer		
Bndry	boundary	Xbuck	cross arm	Eq	environmental sensor station		
Brkwy	breakaway	Xsec	cross buck	Evgr	equal		
Br	bridge	Xing	cross sections	Exc	evergreen		
Bldg	building	Xrd	crossing	Exst	excavation		
Bus.	business	Crn	crossroad	Exp	existing		
BV	butterfly valve		crown	Expy	expansion		
Byp	bypass			E	Expressway		
				Extru	external of curve		
					extruded		

NORTH DAKOTA DEPARTMENT OF TRANSPORTATION	
07-01-14	
REVISIONS	
DATE	CHANGE
04-23-18 09-20-18 12-18-20	General Revisions General Revisions General Revisions

12 18 2020

NDDOT ABBREVIATIONS

D-101-2

Galv	galvanized	Ln	lane	Obsc	obscure(d)	Qty	quantity
Gar	garage	Lg	large	Ocpd	occupied	Qtr	quarter
Gs L	gas line	Lat	latitude	Ocpy	occupy		
G Reg	gas line regulator	Lt	left	O/s	offset		
GMV	gas main valve	Lens	lenses	OC	on center	Rad or R	radius
G Mtr	gas meter	Lvl	level	C	one dimensional consolidation	RR	railroad
GSV	gas service valve	LvIng	leveling	OC	organic content	Rlwy	railway
GVP	gas vent pipe	Lht	light	Orig	original	Rsd	raised
GV	gate valve	LP	light pole	O To O	out to out	RC	rapid curing
Ga	gauge	Ltg	lighting	OD	outside diameter	Rec	record
Gov	government	Liq	liquid	OH	overhead	Rcy	recycle
Grd	graded/grade	LL	liquid limit			RAP	recycled asphalt pavement
Grnd	ground	Loc	location			RPCC	recycled portland cement concrete
GWM	ground water monitor	Long.	longitude	PMT	pad mounted transformer	Ref	reference
Gdrl	guardrail	Lp	loop	Pg	pages	R Mkr	reference marker
Gtr	gutter	LD	loop detector	Pntd	painted	RM	reference monument
		Lum	luminaire	Pr	pair	RP	reference point
				Pnl	panel	Refl	reflectorized
H Plg	H piling			Pk	park	RCB	reinforced concrete box
Hdwl	headwall	Mb	mailbox	PSD	passing sight distance	RCES	reinforced concrete end section
Ht	height	ML	main line	Pvmt	pavement	RCFES	reinforced concrete flared end section
Hel	helical	MH	manhole	Ped	pedestal	RCP	reinforced concrete pipe
HDPE	high density polyethylene	Mkd	marked	Ped	pedestrian	RCPS	reinforced concrete pipe sewer
HM	high mast	Mkr	marker	PPP	pedestrian pushbutton post	RCTES	reinforced concrete traversable end section
HP	high pressure	Mkg	marking	Pen.	penetration	Reinf	reinforcement
HPS	high pressure sodium	MA	mast arm	Perf	perforated	Res	reservation
Hwy	highway	Matl	material	Per.	perimeter	Res	residence
Hor	horizontal	Max	maximum	Perm	permanent	Ret	retaining
HBP	hot bituminous pavement	MC	meander corner	PL	pipeline	Rev	reverse
HMA	hot mix asphalt	Meas	measure	Pl	place	Rt	right
Hyd	hydrant	Mdn	median	P&P	plan & profile	R/W	right of way
Ph	hydrogen ion content	MD	median drain	PL	plastic limit	Riv	river
		MC	medium curing	Pl or \overline{P}	plate	Rd	road
		MGS	Midwest Guardrail System	Pt	point	Rdbd	road bed
Id	identification	MM	mile marker	PE	polyethylene	Rdwy	roadway
Incl	inclinometer tube	MP	mile post	PVC	polyvinyl chloride	RWIS	roadway weather information system
IMH	inlet manhole	Min	minimum	PCC	Portland Cement concrete	Rk	rock
ID	inside diameter	Misc	miscellaneous	PP	power pole	Rt	route
Inst	instrument	Mon	monument	Preempt	preemption		
Intchg	interchange	Mnd	mound	Prefab	prefabricated		
Intmdt	intermediate	Mtbl	mountable	Prfmd or Pref	preformed		
Intscn	intersection	Mtd	mounted	Prep	preperation		
Inv	invert	Mtg	mounting	Press.	pressure		
IP	iron pipe	Mk	muck	PRV	pressure relief valve		
				Prestr	prestressed		
				Pvt	private		
				PD	private drive		
Jt	joint			Prod.	production/produce		
Jct	junction			Prog	programmed		
		Neop	neoprene	Prop.	property		
		Ntwk	network	Prop Ln	property line		
		N	North	Ppsd	proposed		
		NE	North East	PB	pull box		
		NW	North West				
		NB	Northbound				
		No. or #	number				

NORTH DAKOTA DEPARTMENT OF TRANSPORTATION	
07-01-14	
REVISIONS	
DATE	CHANGE
08-03-15 04-23-18 12-18-20	General Revisions General Revisions General Revisions



12 18 2020

NDDOT ABBREVIATIONS

D-101-3

Salv	salvage(d)	Tel	telephone
San	sanitary sewer line	Tel B	Telephone Booth
Sec	section	Tel P	telephone pole
SL	section line	Tv	television
Sep	separation	Temp	temperature
Seq	sequence	Temp	temporary
Serv	service	TBM	temporary bench mark
Sht	sheet	T	thinwall tube sample
Shtng	sheeting	Ts	topsoil
Shldr	shoulder	Traf	traffic
Sw or Sdwk	sidewalk	TSCB	traffic signal control box
SD	sight distance	Tr	trail
SN	sign number	Transf	transformer
Sig	signal	Trans	transition
Sgl	single	TT	transmission tower
SRCP	slotted reinforced concrete pipe	TES	traversable end section
SC	slow curing	Trans	transverse
SS	slow setting	Trtd	treated
Sm	small	Trmt	treatment
S	South	Qc	triaxial compression
SE	South East	TERO	tribal employment rights ordinance
SW	South West	Tpl	triple
SB	Southbound	Typ	typical
Sp	spaces		
Spcl	special	Qu	unconfined compressive strength
SA	special assembly	Ugrnd	underground
SP	special provisions	Util	utility
G	specific gravity		
Spk	spike		
SB	split barrel sample	VG	valley gutter
SH	sprinkler head	Vap	vapor
SV	sprinkler valve	Vert	vertical
Sq	square	VCP	vitrified clay pipe
Stk	stake	Vol	volume
Std	standard		
N	standard penetration test		
Std Specs	standard specifications	Wkwy	walkway
Stm L	steam line	W	water content
SEC	steel encased concrete	WGV	water gate valve
SMA	stone matrix asphalt	WL	water line
SSD	stopping sight distance	WM	water main
SD	storm drain	WMV	water main valve
St	street	W Mtr	water meter
SPP	structural plate pipe	WSV	water service valve
SPPA	structural plate pipe arch	WW	water well
Str	structure	Wrng	wearing
Subd	subdivision	WIM	weigh in motion
Sub	subgrade	W	west
Sub Prep	subgrade preperation	WB	westbound
Ss	subsoil	Wrng	wiring
SS	supplement specification	W/	with
Supp	supplemental	W/o	without
Surf	surfacing	WC	witness corner
Surv	survey		
Sym	symmetrical		

NORTH DAKOTA DEPARTMENT OF TRANSPORTATION	
07-01-14	
REVISIONS	
DATE	CHANGE
08-03-15	General Revisions
04-23-18	General Revisions
12-18-20	General Revisions



12 18 2020

MEASUREMENTS

ac	acres
A	ampere
Bd Ft	board feet
Cd	candela
cm	centimeter
C	coulomb
CF	cubic feet
m3	cubic meter
m3/s	cubic meters per second
CY	cubic yard
CY/mi	cubic yards per mile
D or Deg	degree
F	Fahrenheit
F	farad
ft	feet/foot
Gal	gallon
G	giga
Ha	hectare
H	henry
Hz	hertz
hr	hour(s)
in	inch
J	joule
K	kelvin
kN	kilo newton
kPa	kilo pascal
kg	kilogram
kg/m3	kilogram per cubic meter
km	kilometer
K	Kip(s)
LF	linear foot
L	litre
Lm	lumen
L sum	lump sum
Lx	lux
M Hr	man hour
M	mega
m	meter
m/s	meters per second
mi	mile
mL	milliliter
mm	millimeter
mm/hr	millimeters per hour
n	nano
N	newton
Pa	pascal
lb	pounds
sec	seconds
S	siemens
SF	square feet
km2	square kilometer
m2	square meter
SY	square yard
Sta Yd	station yards
SI	Systems International

T	tesla
T/mi	tons per mile
V	volt
W	watt
Wb	weber

SURVEY DESCRIPTIONS

Az	azimuth
Bs	backsight
Brg	bearing
BP Cap	blue plastic cap
BS	both sides
BC	brass cap
CS	curve to spiral
Eq	equation
E	external of curve
FS	far side
FB	field book
Fs	foresight
Geod	geodetic
GIS	Geographical Information System
GPS	Global Positioning System
HI	height of instrument
IM	iron monument
I Pn	iron pin
LS	Land Surveyor (licensed)
LSIT	Land Surveyor In Training
L	length of curve
LC	long chord
LB	level book
Mer	meridian
M	mid ordinate of curve
NGS	National Geodetic Survey
NS	near side
Obsn	observation
Off Loc	office location
OP Cap	orange plastic cap
PK	Parker-Kalon nail
P Cap	plastic cap
PP Cap	pink plastic cap
PCC	point of compound curve
PC	point of curve
PI	point of intersection
PRC	point of reverse curvature
PT	point of tangent
POC	point on curve
POT	point on tangent
RTP	random traverse point
Rge	range
RP Cap	red plastic cap
SC	spiral to curve
ST	spiral to tangent
Sta	station
SE	superelevation
Tan	tangent
T	tangent (semi)
TS	tangent to spiral
Twp	township
TB	transit book
TP	traverse point
TP	turning point
USC&G	US Coast & Geodetic Survey
USGS	US Geologic Survey
VC	vertical curve
WGS	World Geodetic System
YP Cap	yellow plastic cap
Z	zenith

SOIL TYPES

Cl	clay
Cl F	clay fill
Cl Hvy	clay heavy
Cl Lm	clay loam
Co S	coal slack
C Gr	coarse gravel
CS	coarse sand
FS	fine sand
Gr	gravel
Lig Co	lignite coal
Lig Sl	lignite slack
Lm	loam
Rk	rock
Sd	sand
Sdy Cl	sandy clay
Sdy Cl Lm	sandy clay loam
Sdy Fl	sandy fill
Sdy Lm	sandy loam
Sc	scoria
Sh	shale
Si Cl	silt clay
Si Cl Lm	silty clay loam
Si Lm	silty loam

NORTH DAKOTA DEPARTMENT OF TRANSPORTATION	
07-01-14	
REVISIONS	
DATE	CHANGE
12-18-20	Sheet Added - Continued from D-101-3

KIRK J. HOFF

REGISTERED

PROFESSIONAL

PE-4683

ENGINEER

NORTH DAKOTA

12 18 2020

NDDOT UTILITY COMPANY AND ORGANIZATION ABBREVIATIONS

D-101-10

702COM	702 Communications	GT PLNS NAT GAS	Great Plains Natural Gas Company	RED RIV COMM	Red River Rural Communications
ACCENT	Accent Communications	HALS TEL	Halstad Telephone Company	RESVTN TEL	Reservation Telephone
AGASSIZ WU	Agassiz Water Users Incorporated	IDEA1	Idea1	ROBRTS TEL	Roberts Company Telephone
AGC	Associated General Contractors of America	INT-COMM TEL	Inter-Community Telephone Company	R-RIDER ELEC	Roughrider Electric Cooperative
ALL PL	Alliance Pipeline	KANEB PL	Kaneb Pipeline Company	RRVW	Red River Valley & Western Railroad
ALL SEAS WU	All Seasons Water Users Association	KEM ELEC	Kem Electric Cooperative Incorporated	S CENT REG WD	South Central Regional Water District
AMOCO PI	Amoco Pipeline Company	KOCH GATH SYS	Koch Gathering Systems Incorporated	S E W U	South East Water Users Incorporated
AMRDA HESS	Amerada Hess Corporation	LKHD PL	Lakehead Pipeline Company	SCOTT CABLE	Scott Cable Television Dickinson
AT&T	AT&T Corporation	LNGDN RWU	Langdon Rural Water Users Incorporated	SHERDN ELEC	Sheridan Electric Cooperative
B PAW	Bear Paw Energy Incorporated	LWR YELL R ELEC	Lower Yellowstone Rural Electric	SHEYN VLY ELEC	Sheyenne Valley Electric Cooperative
BAKER ELEC	Baker Electric	MCKNZ CON	McKenzie Consolidated Telcom	SKYTECH	Skyland Technologies Incorporated
BASIN ELEC	Basin Electric Cooperative Incorporated	MCKNZ ELEC	McKenzie Electric Cooperative	SLOPE ELEC	Slope Electric Cooperative Incorporated
BEK TEL	Bek Communications Cooperative	MCKNZ WRD	McKenzie County Water Resource District	SOURIS RIV TELCOM	Souris River Telecommunications
BELLE PL	Belle Fourche Pipeline Company	MCLEOD	McLeod USA	ST WAT COMM	State Water Commission
BLM	Bureau of Land Management	MCLN ELEC	McLean Electric Cooperative	STATE LN WATER	State Line Water Cooperative
BNSF	Burlington Northern Santa Fe Railway	MCLN-SHRDN R WAT	McLean-Sheridan Rural Water	STER ENG	Sterling Energy
BOEING	Boeing	MDU	Montana-dakota Utilities	STUT RWU	Stutsman Rural Water Users
BRNS RWD	Barnes Rural Water District	MIDCO	MidContinent Communications	SW PL PRJ	Southwest Pipeline Project
BURK-DIV ELEC	Burke-Divide Electric Cooperative	MIDSTATE TEL	Midstate Telephone Company	T M C	Turtle Mountain Communications
BURL WU	Burleigh Water Users	MINOT CABLE	Minot Cable Television	TCI	TCI of North Dakota
CABLE ONE	Cable One	MINOT TEL	Minot Telephone Company	TESORO HGH PLNS PL	Tesoro High Plains Pipeline
CABLE SERV	Cable Services	MISS VALL COMM	Missouri Valley Communications	TRI-CNTY WU	Tri-County Water Users Incorporated
CAP ELEC	Capital Electric Cooperative Incorporat	MISS W W S	Missouri West Water System	TRL CO RWU	Traill County Rural Water Users
CASS CO ELEC	Cass County Electric Cooperative	MNKOTA PWR	Minnkota Power	UNTD TEL	United Telephone
CASS RWU	Cass Rural Water Users Incorporated	MOR-GRAN-SOU ELEC	Mor-gran-sou Electric Cooperative	UPPR SOUR WUA	Upper Souris Water Users Association
CAV ELEC	Cavalier Rural Electric Cooperative	MOUNT-WILLI ELEC	Mountrail-williams Electric Cooperative	US SPRINT	U.S. Sprint
CBLCOM	Cablecom Of Fargo	MRE LBTY TEL	Moore & Liberty Telephone	USAF MSL CABLE	U.S.A.F. Missile Cable
CENEX PL	Cenex Pipeline	MUNICIPAL	City Water And Sewer	USFWS	US Fish and Wildlife Service
CENT PL WATER DIST	Central Pipe Line Water District	MUNICIPAL	City Of '.....'	USW COMM	U.S. West Communications
CENT PWR ELEC	Central Power Electric Cooperative	N CENT ELEC	North Central Electric Cooperative	VRNDRY ELEC	Verendrye Electric Cooperative
CENTURYLINK	CenturyLink	N VALL W DIST	North Valley Water District	W RIV TEL	West River Telephone Incorporated
COE	Corps of Engineers	ND PKS & REC	North Dakota Parks And Recreation	WAPA	Western Area Power Administration
CONS TEL	Consolidated Telephone	ND TEL	North Dakota Telephone Company	WEB	W. E. B. Water Development Association
CONT RES	Continental Resource Inc	NDDOT	North Dakota Department of Transportation	WILLI RWA	Williams Rural Water Association
CPR	Canadian Pacific Railway	NDSU SOIL SCI DEPT	NDSU Soil Science Department	WILSTN BAS PL	Williston Basin Interstate Pipeline Company
D O E	Department Of Energy	NEMONT TEL	Nemont Telephone	WLSH RWD	Walsh Water Rural Water District
DAK CARR	Dakota Carrier Network	NODAK R ELEC	Nodak Rural Electric Cooperative	WOLVRTN TEL	Wolverton Telephone
DAK CENT TEL	Dakota Central Telephone	NOON FRMS TEL	Noonan Farmers Telephone Company	XLENER	Xcel Energy
DAK RWD	Dakota Rural Water District	NPR	Northern Plains Railroad	YSVR	Yellowstone Valley Railroad
DGC	Dakota Gasification Company	NSP	Northern States Power		
DICKEY R NET	Dickey Rural Networks	NTH PRAIR RW	Northern Prairie Rural Water Association		
DICKEY RWU	Dickey Rural Water Users Association	NTHN BRDR PL	Northern Border Pipeline		
DICKEY TEL	Dickey Telephone	NTHN PLNS ELEC	Northern Plains Electric Cooperative Incorporated		
DNRR	Dakota Northern Railroad	NTHWSTRN REF	Northwestern Refinery Company		
DOME PL	Dome Pipeline Company	NW COMM	Northwest Communication Cooperation		
DVELEC	Dakota Valley Electric Cooperative	NWRWD	Northwest Rural Water District		
DVMW	Dakota, Missouri Valley & Western	ONEOK	Oneok gas		
ENBRDG	Enbridge Pipelines Incorporated	OSHA	Occupational Safety and Health Administration		
ENVENTIS	Enventis Telephone	OTTR TL PWR	Otter Tail Power Company		
FALK MNG	Falkirk Mining Company	P L E M	Prairielands Energy Marketing		
FHWA	Federal Highway Administration	POLAR COM	Polar Communications		
G FKS-TRL WD	Grand Forks-traill Water District	PVT ELEC	Private Electric		
GETTY TRD & TRAN	Getty Trading & Transportation	QWEST	Qwest Communications		
GLDN W ELEC	Golden West Electric Cooperative	R&T W SUPPLY	R & T Water Supply Association		
GRGS CO TEL	Griggs County Telephone				
GTR RAMSEY WD	Greater Ramsey Water District				

NORTH DAKOTA DEPARTMENT OF TRANSPORTATION	
07-01-14	
REVISIONS	
DATE	CHANGE
04-23-18 09-20-18 12-18-20	General Revisions General Revisions General Revisions

KIRK J. HOFF

REGISTERED

PROFESSIONAL

PE-4683

ENGINEER

 






















NORTH DAKOTA






 
 







12 18 2020

LINE STYLES



 





D-101-20

Existing Topography









 













	Existing Ground Void
	Existing Cemetary Boundary
	Existing Box Culvert Bridge
	Existing Concrete Surface
	Existing Drainage Structure
	Existing Gravel Surface
	Existing Riprap
	Existing Dirt Surface
	Existing Asphalt Surface
	Existing Tie Point Line
	Existing Railroad Centerline
	Existing Guardrail Cable
	Existing Guardrail Metal
	Existing Edge of Water
	Existing Fence
	Existing Railroad
	Existing Field Line
	Exst Flow
	Existing Curb
	Existing Valley Gutter
	Existing Driveway Gutter
	Existing Curb and Gutter
	Existing Mountable Curb and Gutter

	Existing 3-Cable w Posts
	Site Boundary
	Existing Berm, Dike, Pit, or Earth Dam
	Existing Ditch Block
	Existing Tree Boundary
	Existing Brush or Shrub Boundary
	Existing Retaining Wall
	Existing Planter or Wall
	Existing W-Beam Guardrail with Posts
	Existing Railroad Switch
	Gravel Pit - Borrow Area
	Existing Wet Area-Vegetation Break
	Existing High Tension Cable Guardrail
	Existing High Tension Cable Guardrail with Posts




 
Proposed Topography

	3-Cable w Posts
	Flow
	Fence
	Remove Line
	Wall
	Retaining Wall (Plan View)
	W-Beam w Posts
	High Tension Cable Guardrail with Posts






 
 


Existing Utilities

	Existing Electrical
	Existing Fiber Optic Line
	Existing TV Fiber Optic
	Existing Gas Pipe
	Existing Overhead Utility Line
	Existing Power
	Existing Fuel Pipeline
	Existing Undefined Above Ground Pipe Line
	Existing Sanitary Sewer
	Existing Sanitary Force Main
	Existing Storm Drain
	Existing Storm Drain Force Main
	Existing Culvert
	Existing Telephone Line
	Existing TV Line
	Existing Water or Steam Line
	Existing Under Drain
	Existing Slotted Drain
	Existing Conduit
	Existing Conductor
	Existing Down Guy Wire Down Guy
	Existing Underground Vault or Lift Station




Proposed Utilities


	24 Inch Pipe
	Reinforced Concrete Pipe
	Under Drain
	Edge Drain

Traffic Utilities

	Conductor
	Fiber Optic
	Existing Loop Detector
	Existing Double Micro Loop Detector
	Micro Loop Detector Double
	Existing Micro Loop Detector
	Micro Loop Detector
	Signal Head with Mast Arm
	Existing Signal Head with Mast Arm

Sign Structures






 







	Existing Overhead Sign Structure
	Existing Overhead Sign Structure Cantilever
	Overhead Sign Structure Cantilever

NORTH DAKOTA DEPARTMENT OF TRANSPORTATION		
07-01-14 REVISIONS		
DATE	CHANGE	
09-23-16 12-18-20	Added and Revised Items, Organized by Functional Groups General Revisions	
		12 18 2020










LINE STYLES

D-101-21









Right Of Way

	Easement
	Existing Easement
	Right of Way
	Existing Right of Way
	Existing Right of Way Railroad
	Existing Right of Way Not State Owned
	Existing Government Lot Line
	Existing Adjacent Block Lines
	Existing Adjacent Lot Lines
	Existing Adjacent Property Line
	Existing Adjacent Subdivision Lines
	Sight Distance Triangle Line
	Dimension Leader



 




Boundary Control

	Existing City Corporate Limits or Reservation Boundary
	Existing State or International Line
	Existing Township
	Existing County
	Existing Section Line
	Existing Quarter Section Line
	Existing Sixteenth Section Line
	Existing Centerline
	Tangent Line



Cross Sections and Typicals

	Existing Ground
	Existing Topsoil (Cross Section View)
	Existing Ground Void (Not Surveyed)
	Existing Concrete
	Existing Aggregate (Cross Section View)
	Existing Curb and Gutter (Cross Section View)
	Existing Asphalt (Cross Section View)
	Existing Reinforcement Rebar

 

Geotechnical

	Geotextile Fabric Type D
	Geogrid
	Geotextile Fabric Type R
	Geotextile Fabric Type R1
	Geotextile Fabric Type RR
	Geotextile Fabric Type S
	Subgrade Reinforcement







Countours

	Depression Contours
	Supplemental Contour




 
Profile

	Subgrade, Subcut or Ditch Grade
	Topsoil Profile










Striping

	Centerline Pavement Marking
	Barrier with Centerline Pavement Marking
	Barrier Pavement Marking
	Stripe 4 IN Dotted Extension White
	Stripe 8 IN Dotted Extension White
	Stripe 8 IN Lane Drop








Pavement Joints

	Doweled Joint
	Tie Bar 30 Inch 4 Foot Center to Center
	Tie Bar 18 Inch 3 Foot Center to Center
	Tie Bar at Random Spacing






Bridge Details

	Small Hidden Object
	Large Hidden Object
	Phantom Object
	Existing Conditions Object
	Centerline Main
	Centerline Secondary
	Excavation Limits
	Proposed Ground
	Sheet Piling

Erosion Control

	Limits of Const Transition Line
	Bale Check
	Rock Check
	Floating Silt Curtain
	Silt Fence
	Excavation Limits
	Fiber Rolls

Environmental


	Wetland Mitigation
	Existing Wetland Easement USFWS
	Existing Wetland Jurisdictional
	Existing Wetland
	Tree Row

NORTH DAKOTA
DEPARTMENT OF TRANSPORTATION

07-01-14

REVISIONS

DATE	CHANGE
09-23-16 12-18-20	Added and Revised Items, Organized by Functional Groups General Revisions



12 18 2020


SYMBOLS

D-101-30


 North Arrow (Half Scale)

 Alignment Data Point

 Alignment Monument

 Spot Elevation

 Existing Miscellaneous Spot

 Existing Access Control Arrow

 Existing Benchmark

 Reset USGS Marker

 Iron Monument Found

 Iron Pin R/W Monument

 Property Corner

 Iron Pin Reference Monument

   Right of Way Marker (Exst, Ppsd, Reset)

 Existing Federal Reference Corner

    Existing Section Corner (Full, Quarter, Sixteenth, Meander)

 Existing Witness Corner


   Existing Control Point (CP, GPS-RTK, TRI)

 Existing Traverse PI Aerial Panel

 Existing Reference Marker Point NGS

 Existing EFB Misc

 Existing Bush or Shrub

 Existing Large Evergreen Tree

 Existing Small Evergreen Tree

 Existing Large Tree

 Existing Small Tree

 Existing Tree Trunk

 Cairn or Stone Circle


 Existing Artifact

 Existing Satellite Dish

 Existing Weather Station

 Existing Windmill or Tower

 Reinforced Pavement


 Continuous Split Barrel Sample

 Flight Auger Sample

 Split Barrel Sample

 Thinwall Tube Sample

 Standard Penetration Test

 Inclinometer Tube

 Excavation Unit

 Existing Ground Water Well Bore Hole

NORTH DAKOTA DEPARTMENT OF TRANSPORTATION	
07-01-14	
REVISIONS	
DATE	CHANGE
12-18-20	General Revisions

KIRK J. HOFF

REGISTERED

PROFESSIONAL

PE-4683





































ENGINEER

NORTH DAKOTA


12 18 2020

SYMBOLS

D-101-31

	Flexible Delineator		Highway Sign (Exst, Ppsd)
	Flexible Delineator Type A (Exst, Ppsd)		Mile Post Type A (Exst-Ppsd-Reset)
	Flexible Delineator Type B (Exst, Ppsd)		Mile Post Type B (Exst, Ppsd)
	Flexible Delineator Type C (Exst, Ppsd)		Mile Post Type C (Exst, Ppsd)
	Flexible Delineator Type D (Exst, Ppsd)		Object Marker Type I (Exst, Ppsd)
	Flexible Delineator Type E (Exst, Ppsd)		Object Marker Type II (Exst, Ppsd)
	Delineator Type A (Exst, Ppsd, Diamond Grade-Reset)		Object Marker Type III (Exst, Ppsd)
	Delineator Type B (Exst, Ppsd, Diamond Grade-Reset)		Existing Reference Marker
	Delineator Type C (Exst, Ppsd, Diamond Grade)		Road Closure Gate 18 Ft (Exst, Ppsd)
	Delineator Type D (Exst, Ppsd, Diamond Grade)		Road Closure Gate 28 Ft (Exst, Ppsd)
	Delineator Type E (Exst, Ppsd, Diamond Grade)		Road Closure Gate 40 Ft (Exst, Ppsd)
	Barricade (Type I, Type II, Type III)		Existing Railroad Battery Box
	Arrow Panel (Caution Mode, Double Direction, Left Directional, Right Directional, Sequencing, Truck Mounted)		Existing RR Profile Spot
	Attenuation Device		Existing Railroad Crossbuck
	Truck Mounted Attenuator		Existing Railroad Frog
	Delineator Drums		Existing Mailbox (Private, Federal)
	Flagger		
	Tubular Marker		
	Traffic Cone		
	Back to Back Vertical Panel Sign		







 








 









 



















 















 


















NORTH DAKOTA DEPARTMENT OF TRANSPORTATION	
07-01-14	
REVISIONS	
DATE	CHANGE
12-18-20	General Revisions




12 18 2020

SYMBOLS


D-101-32

	Existing Luminaire			High Mast Light Standard 3 Luminaire (Exst, Ppsd)		Existing Traffic Signal Standard			
	Luminaire LED			High Mast Light Standard 4 Luminaire (Exst, Ppsd)				Pull Box (Exst-Ppsd-Undefined)	
	Existing Light Standard Luminaire			High Mast Light Standard 5 Luminaire (Exst, Ppsd)				Intelligent Transportation Pull Box (Exst, Ppsd)	
	Relocate Light Standard			High Mast Light Standard 6 Luminaire (Exst, Ppsd)				Transformer (Exst, Ppsd)	
	Light Standard Light LED Luminaire			High Mast Light Standard 7 Luminaire (Exst, Ppsd)				Power Pole (Exst-Ppsd-with Transformer)	
	Light Standard 35 Watt High Pressure Sodium Vapor Luminaire			High Mast Light Standard 8 Luminaire (Exst, Ppsd)				Wood Pole (Exst, Ppsd)	
	Light Standard 50 Watt High Pressure Sodium Vapor Luminaire			High Mast Light Standard 9 Luminaire (Exst, Ppsd)				Pedestrian Push Button Post (Exst, Ppsd)	
	Light Standard 70 Watt High Pressure Sodium Vapor Luminaire			High Mast Light Standard 10 Luminaire (Exst, Ppsd)				Existing Pole	
	Light Standard 100 Watt High Pressure Sodium Vapor Luminaire			Overhead Sign Structure Load Center (Exst, Ppsd)				Existing Telephone Pole	
	Light Standard 150 Watt High Pressure Sodium Vapor Luminaire			Traffic Signal Controller (Exst, Ppsd)				Existing Post	
	Light Standard 200 Watt High Pressure Sodium Vapor Luminaire			Pad Mounted Traffic Signal Controller (Exst, Ppsd)					Connection Conductor (Ground, Neutral, Phase 1, Phase 2)
	Light Standard 250 Watt High Pressure Sodium Vapor Luminaire			Flashing Beacon (Exst, Ppsd)					
	Light Standard 310 Watt High Pressure Sodium Vapor Luminaire			Concrete Foundation (Exst, Ppsd)					
	Light Standard 400 Watt High Pressure Sodium Vapor Luminaire			Pipe Mounted Flasher (Exst, Ppsd)					
	Light Standard 700 Watt High Pressure Sodium Vapor Luminaire			Pad Mounted Feed Point (Exst, Ppsd)					
	Light Standard 1000 Watt High Pressure Sodium Vapor Luminaire			Pipe Mounted Feed Point with Pad (Exst, Ppsd)					
	Emergency Vehicle Detector			Pole Mounted Feed Point (Exst, Ppsd)					
	Video Detection Camera			Junction Box (Exst, Ppsd)					
				Existing Pedestrian Head with Number					
				Existing Signal Head					
				Pole Mounted Head					
				Existing Lighting Standard Pole					

NORTH DAKOTA DEPARTMENT OF TRANSPORTATION	
07-01-14	
REVISIONS	
DATE	CHANGE
12-18-20	General Revisions



NORTH DAKOTA DEPARTMENT OF TRANSPORTATION	
07-01-14 REVISIONS	
DATE	CHANGE
12-18-20	General Revisions



12 18 2020

SYMBOLS

D-101-33

			Existing Manhole (Electrical, Gas, Telephone)		Cap or Stub Exst Gas, Exst Sanitary, Exst Storm Drain, Ppsd Storm Drain, Exst Water
			Water Manhole (Exst, Exst with Valve)		Existing Pedestal Electrical, Telephone, Fiber Optic Telephone, TV, Fiber Optic TV, Undefined
			Sanitary Sewer Manhole (Exst, Ppsd, Exst with Valve)		Existing Pipe Vent Gas, Fuel, Sanitary, Storm Drain, Water, Undefined
			Sanitary Force Main Manhole (Exst, Ppsd, Exst with Valve)		Valve Exst Gas, Exst Water, Ppsd Water, Exst Undefined
			Storm Drain Manhole (Exst, Ppsd, Exst with Inlet, Ppsd with Inlet)		Pump Sanitary, Storm Drain, Exst Water
			Force Main Storm Drain Manhole (Exst, Exst with Valve)		Corrugated Metal End Section (18, 24, 30, 36, 42, 48, 54, 60 Inch)
			Manhole (Ppsd, Ppsd 48 Inch, Exst Undefined)		Reinforced Concrete End Section (18, 24, 30, 36, 42, 48, 54, 60 Inch)
			Existing Water Appurtenance		Existing Utility Marker
			Sprinkler Head (Exst, Ppsd)		Existing Meter
			Fire Hydrant (Exst, Ppsd)		Existing Fuel Dispensers
			Cleanout (Exst Sanitary, Underdrain)		Existing Fuel Filler Pipes
			Existing Catch Basin Inlet (Round, Square)		Existing Fuel Leak Sensors
			Existing Curb Inlet (Round, Square)		
			Existing Slotted Reinforced Concrete Pipe		
			Catch Basin (Riser 30 Inch, Beehive, Type A)		
			Inlet Mountable Curb (Type A, Type B)		
			Inlet Saddle Base (Type 1, Type 2)		
			Inlet Special (Catch Basin, Type 1, Type A)		
			Inlet (Tee, Type 1, Type 2, Type 2 Double)		
			Median Drain		
			Headwall (Exst, Ppsd, Ppsd Single with Vegetation Barrier, Ppsd Double with Vegetation Barrier)		

NORTH DAKOTA DEPARTMENT OF TRANSPORTATION	
07-01-14	
REVISIONS	
DATE	CHANGE
12-18-20	General Revisions Sheet added - Continued from D-101-32

12 18 2020

CONSTRUCTION SIGN DETAILS
PROJECT FUNDING SIGN

D-704-6

SIGN NUMBER	I2-5-96
WIDTH X HEIGHT	8'-0" x 4'-0"
BORDER WIDTH	1.25" (inset 0.75")
CORNER RADIUS	3"
MOUNTING	Ground
BACKGROUND	TYPE: XI Reflective COLOR: White
LEGEND/BORDER	TYPE: Non-reflective COLOR: Black

SYMBOL	X	Y	WID	HT	ANGLE
ND_CIRCLE_LOGO	6	22.8	18	18	0
	44.2	4.2	7.5	8.6	0

STATION(S):

AREA: 32.0 Sq.Ft.

Dimensions are in inches,tenths

Letter locations are panel edge to lower left corner

PANEL STYLE: ND_Reg_48_Large.ssi

LETTER POSITION (X)																		LENGTH	SIZE	SERIES	
Y	O	U	R	H	I	G	H	W	A	Y									50.3	6	C 2000
33.5	38.1	42.8	47.5	55.4	60.1	62.1	66.7	70.9	75.8	80											
D	O	L	L	A	R	S	A	T	W	O	R	K							62.6	6	C 2000
27.4	31.8	36.5	40.4	43.9	48.5	52.6	60.5	64.7	72.2	77.5	82.3	86.6									
F	U	N	D	E	D	B	Y												25	4	C 2000
35.5	38.1	41.2	44.3	47.4	50.1	55.3	57.9														

(A)

FUNDING SOURCE MESSAGE VARIATIONS
FEDERAL
STATE
FEDERAL - STATE
FEDERAL - LOCAL
FEDERAL - STATE - LOCAL
STATE - LOCAL

Use a horizontal spacing of 3" between words and hyphens. Center message horizontally in sign panel.

Notes:




- 1)
- Contact the Communications Division of the NDDOT to obtain a copy of the image for the NDDOT Logo.
- 2)
- Contact Project Engineer for funding source message.

NORTH DAKOTA DEPARTMENT OF TRANSPORTATION	
12-08-21	
REVISIONS	
DATE	CHANGE

This document was originally issued and sealed by
Kirk Hoff,
Registration Number
PE-4683,
on 12/08/21 and the original document is stored at the North Dakota Department of Transportation

Perforated Tube

- Notes:
1. Torque slip base bolts as specified by manufacturer.
 2. Use anchor with 43.9 KSI yield strength and 59.3 KSI tensile strength.
 3. Provide 4" vertical clearance for anchor or breakaway base. Measure the 4"x60" measurement above and below post location and back and ahead of post.
 4. In concrete sidewalk, use same anchor without wings.
 5. Provide more than 7' between the first and fourth posts of a four post sign.

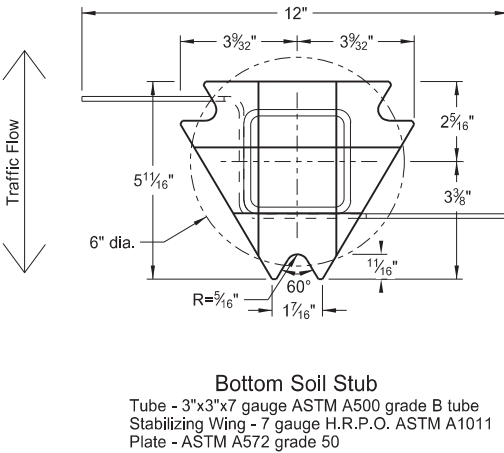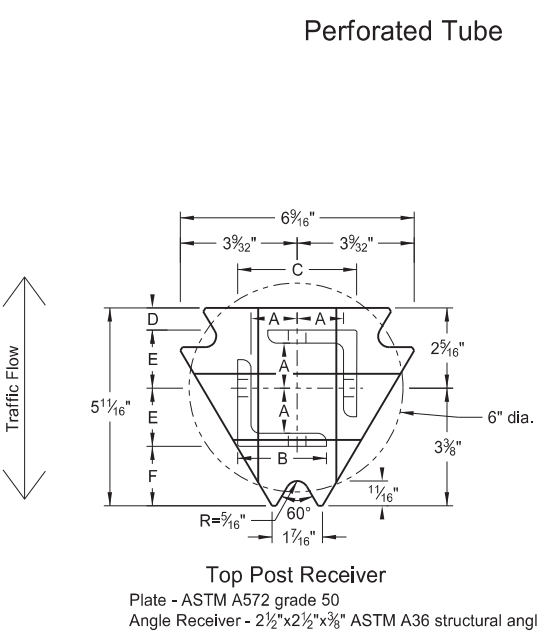
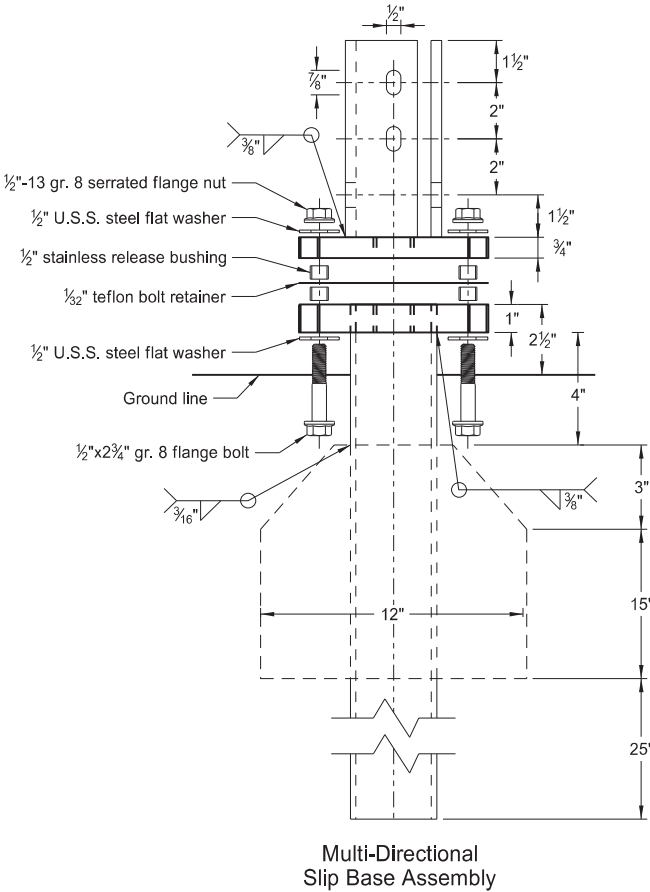


Telescoping Perforated Tube						
Number of Posts	Post Size in.	Wall Thick-ness Gauge	Sleeve Size in.	Wall Thick-ness Gauge	Slip Base	Anchor Size without Slip Base in.
1	2	12			No	2 1/4
1	2 1/4	12			No	2 1/2
1	2 1/2	12			(A)	3
1	2 1/2	10			Yes	
1	2 1/4	12	2	12	Yes	
1	2 1/2	12	2 1/4	12	Yes	
2	2	12			No	2 1/4
2	2 1/4	12			No	2 1/2
2	2 1/2	12			Yes	
2	2 1/2	12			Yes	
2	2 1/4	10	2	12	Yes	
2	2 1/2	12	2 1/4	12	Yes	
3 & 4	2 1/2	12			Yes	
3 & 4	2 1/2	10			Yes	
3 & 4	2 1/2	12	2 1/4	12	Yes	
3 & 4	2 1/4	12	2	12	Yes	
3 & 4	2 1/2	10	2 3/16	10	Yes	

Properties of Telescoping Perforated Tube						
Tube Size in.	Wall Thickness in.	U.S. Standard Gauge	Weight per Foot lbs.	Moment of Inertia in. ⁴	Cross Sec. Area in. ²	Section Modulus in. ³
1 1/2 x 1 1/2	0.105	12	1.702	0.129	0.380	0.172
2 x 2	0.105	12	2.416	0.372	0.590	0.372
2 1/4 x 2 1/4	0.105	12	2.773	0.561	0.695	0.499
2 3/8 x 2 3/8	0.135	10	3.432	0.605	0.841	0.590
2 1/2 x 2 1/2	0.105	12	3.141	0.804	0.803	0.643
2 1/2 x 2 1/2	0.135	10	4.006	0.979	1.010	0.785






Top Post Receiver Data Table						
Square Post Sizes (B)	A	B	C	D	E	F
2 3/16"x10 ga.	1 5/16"	2 1/2"	3 1/2"	2 5/32"	1 33/64"	1 7/8"
2 1/2"x10 ga.	1 3/32"	2 1/2"	3 5/16"	5/8"	1 21/32"	1 3/4"

- (A) Use breakaway base when support is placed in weak soils. Engineer determines if soils are weak.
- (B) For additional wind load, insert the 2 3/8"x10 ga. into 2 1/2"x10 ga.

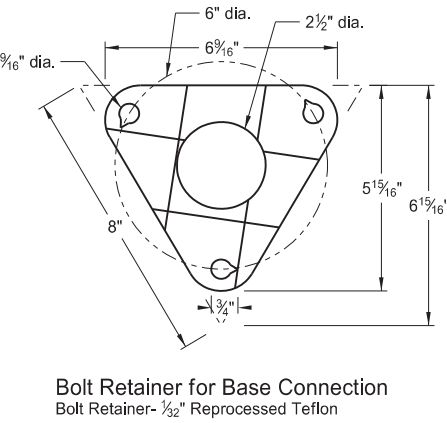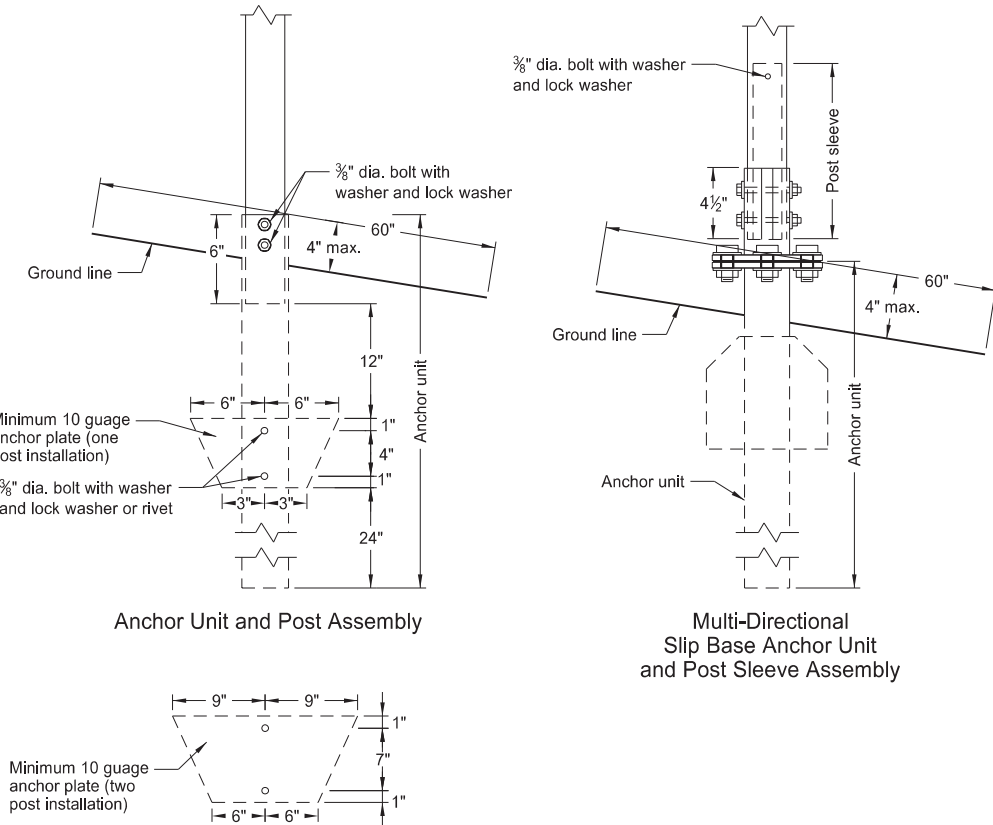

NORTH DAKOTA DEPARTMENT OF TRANSPORTATION		This document was originally issued and sealed by Kirk J Hoff, Registration Number PE- 4683, on 10/03/19 and the original document is stored at the North Dakota Department of Transportation
2-28-14		
REVISIONS		
DATE	CHANGE	
9-27-17 10-03-19	Updated to active voice New Design Engr PE Stamp	

U-Channel Post

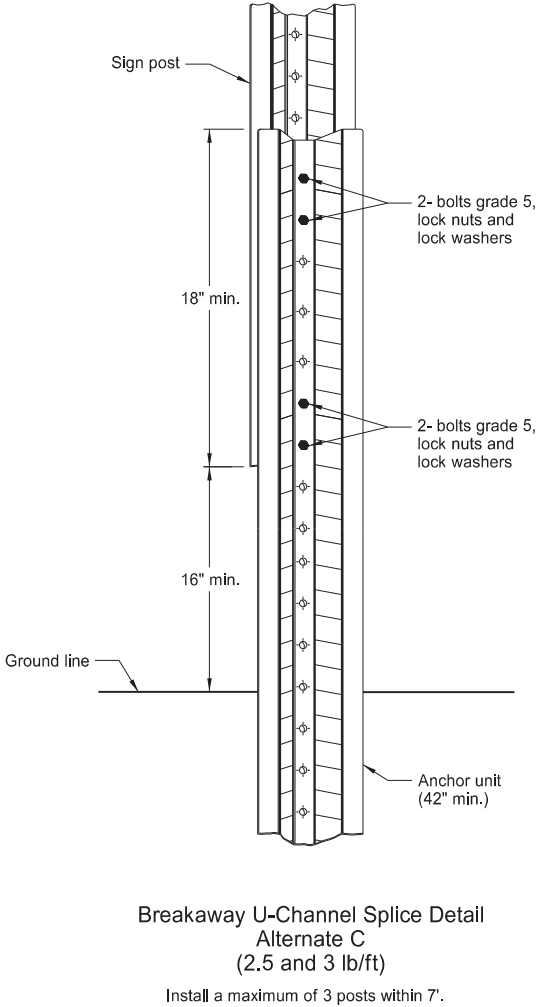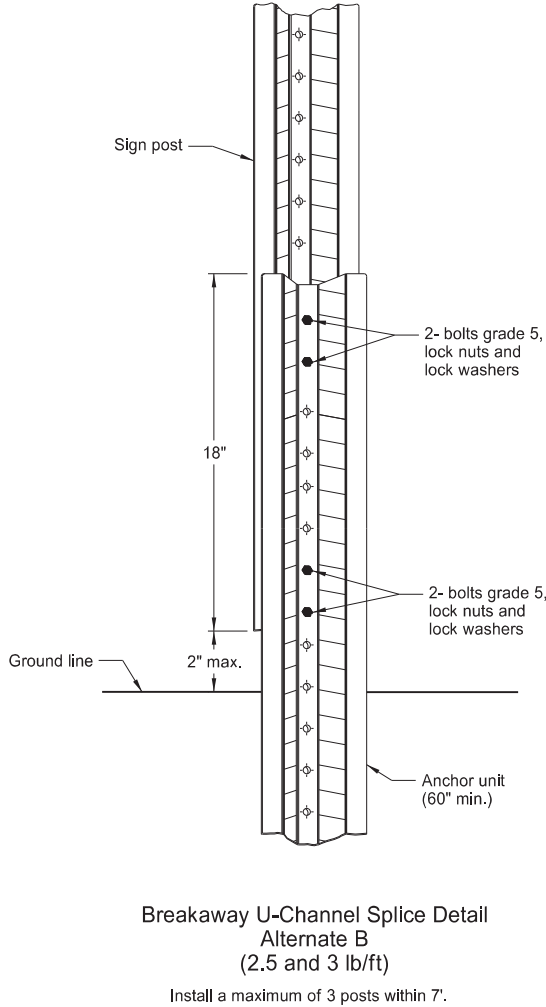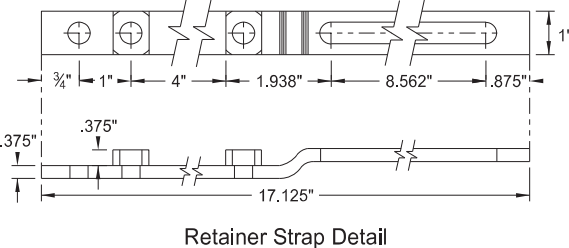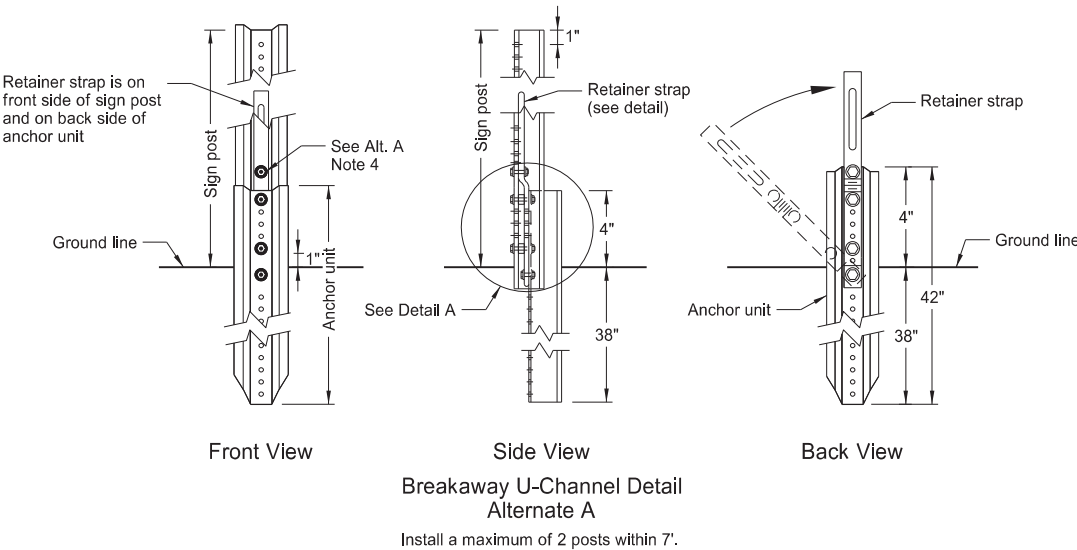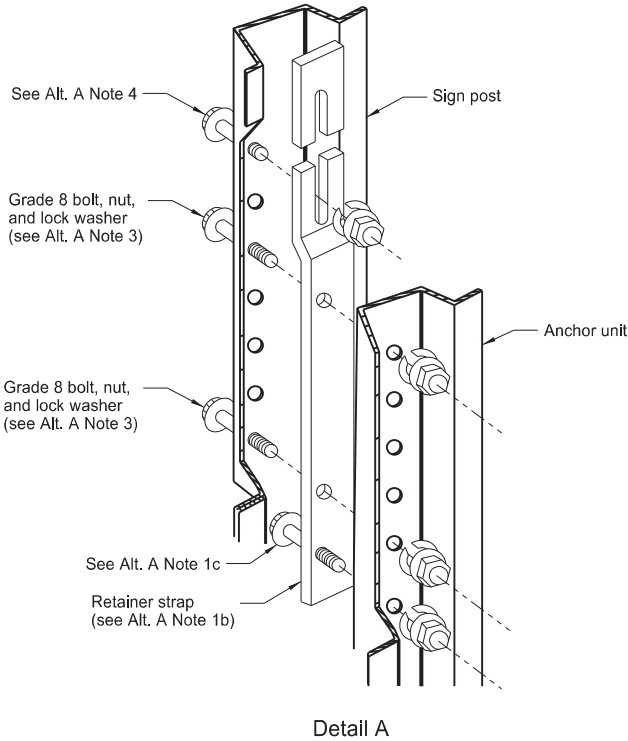

Alternate A Steps of Installation:


- a) Drive anchor unit to within 12" of ground level.
b) Establish proper assembly by lining up bottom hole of retainer strap with 6th hole from the top of the anchor unit.
c) Assemble strap to back of anchor unit using 5/16"x2" bolt, lock washer and nut.
d) Rotate strap 90° to left.
- a) Drive anchor unit to 4" above ground.
b) Rotate strap to vertical position.
- a) Place 5/16"x2" bolt, lock washer and nut in bottom of sign post to facilitate alignment of sign post with proper hole in anchor unit.
b) Alternately tighten two connector bolts.
- Complete assembly by tightening 5/16"x2" bolt (this fastens sign post to retainer strap).
- Properly nest base post, strap, and sign post. Proper nesting occurs when all flat surfaces of the base post, strap, and sign post at the bolts have full contact across the entire width.

NORTH DAKOTA DEPARTMENT OF TRANSPORTATION	
2-28-14	
REVISIONS	
DATE	CHANGE
9-27-17 10-03-19	Updated to active voice New Design Engr PE Stamp


This document was originally issued and sealed by
Kirk J Hoff,
Registration Number
PE- 4683,
on 10/03/19 and the original document is stored at the North Dakota Department of Transportation

CONSTRUCTION SIGN DETAILS
TERMINAL AND GUIDE SIGNS


D-704-9

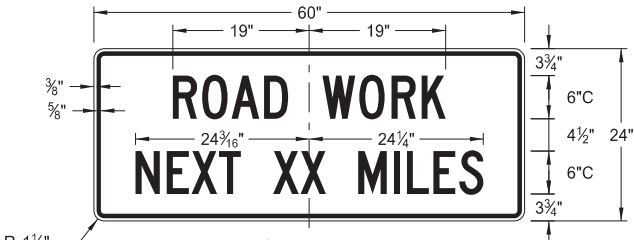


G20-1-60
Legend: black (non-refl)
Background: orange

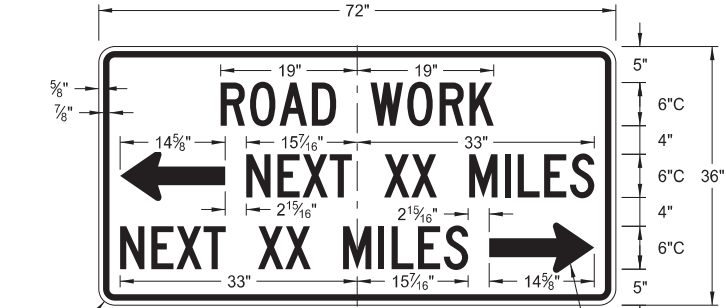


G20-50a-72
Legend: black (non-refl)
Background: orange

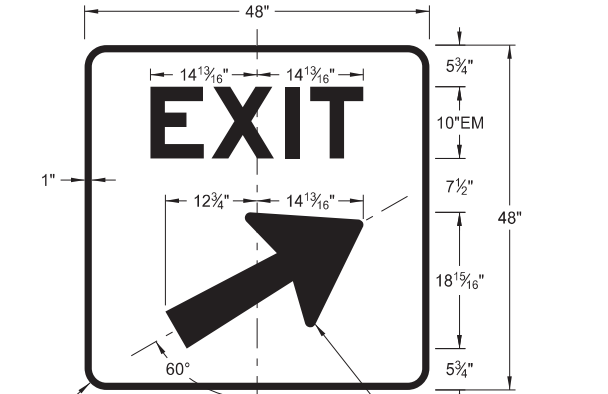


E5-1(L or R)-48
Legend: white
Background: green (orange optional)

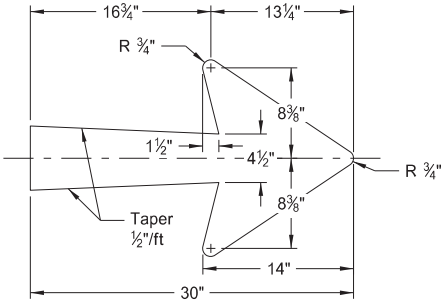


E5-1-48

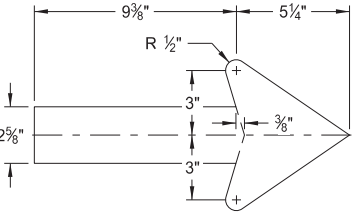


G20-50a-72
G20-52a-72

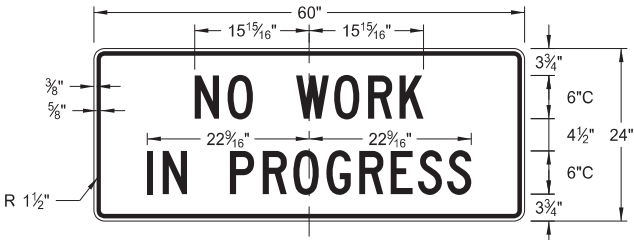


G20-1b-60
Legend: black (non-refl)
Background: orange

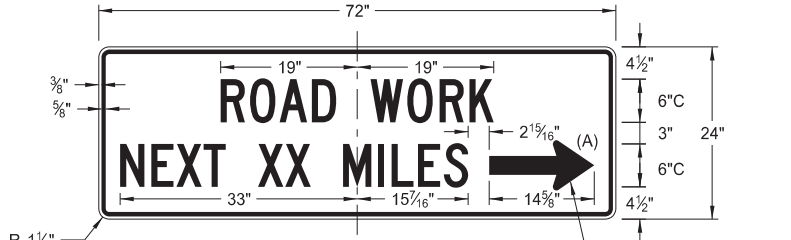


G20-52a-72
Legend: black (non-refl)
Background: orange

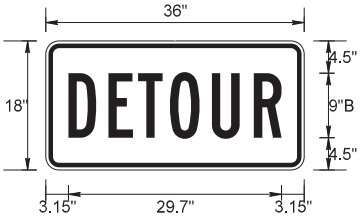


M4-8-36
Legend: black (non-refl)
Background: orange

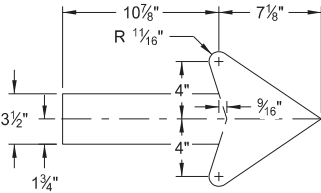


M4-9(L or R)-30
Right or Left

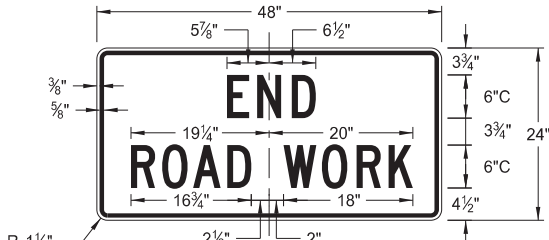


G20-2-48
Legend: black (non-refl)
Background: orange

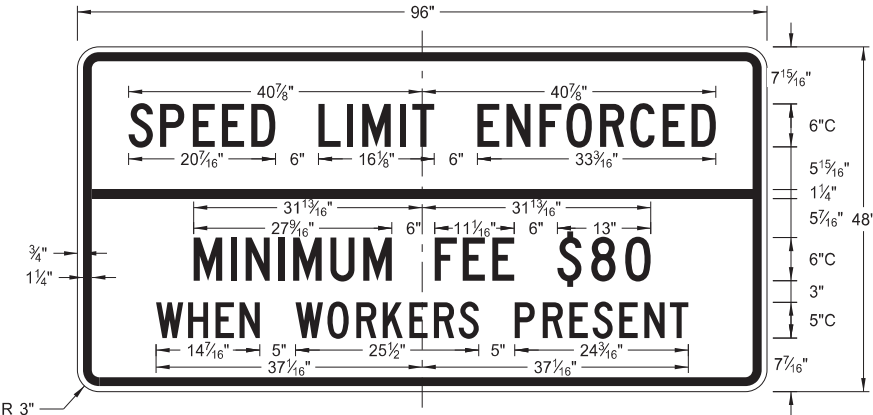


G20-55-96
Legend: black (non-refl)
Background: orange

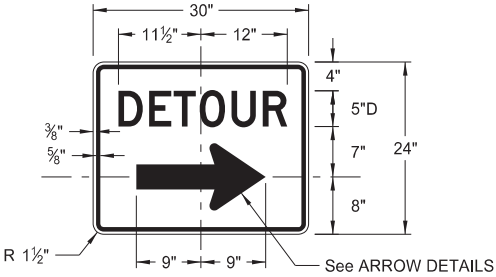

M4-9(L or R)-30 &
M4-9-30
Legend: black (non-refl)
Background: orange

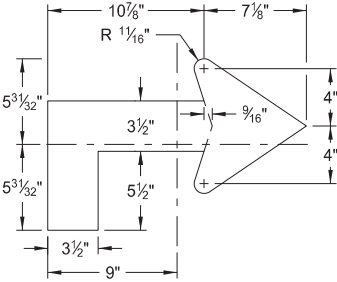

M4-9(L or R)-30
Advanced Right or Left

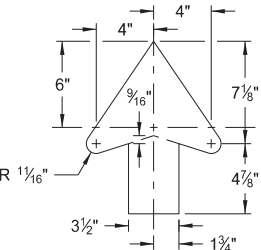






M4-9-30
Straight

ARROW DETAILS

NOTES:
(A) Arrow may be right or left of the legend to indicate construction to the right or left.

NORTH DAKOTA DEPARTMENT OF TRANSPORTATION	
8-13-13	
REVISIONS	
DATE	CHANGE
8-17-17 10-03-19	Added sign & background color New Design Engineer PE Stamp

     This document was originally issued and sealed by
Kirk J Hoff,
Registration Number
PE- 4683,
on 10/03/19 and the original document is stored at the
North Dakota Department
of Transportation



NORTH DAKOTA DEPARTMENT OF TRANSPORTATION	
8-13-13	
REVISIONS	
DATE	CHANGE
8-17-17 10-03-19	Revised sign number New Design Engineer PE Stamp

This document was originally issued and sealed by

Kirk J Hoff,

Registration Number


PE- 4683 ,

on 10/03/19 and the original document is stored at the

North Dakota Department of Transportation


CONSTRUCTION SIGN DETAILS
WARNING SIGNS

D-704-11

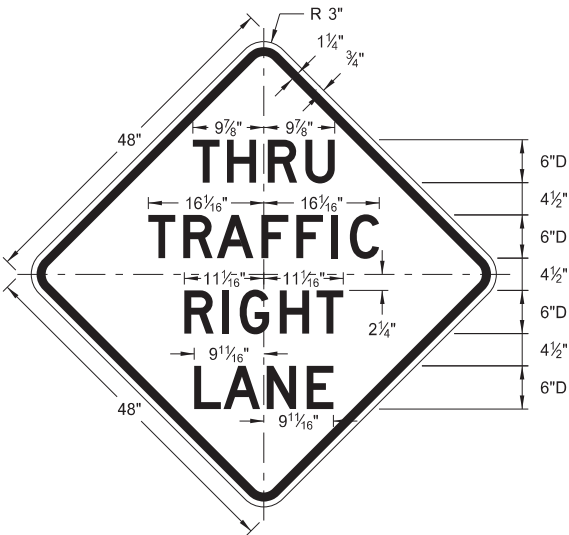


W5-8-48

Legend: black (non-refl)
Background: orange

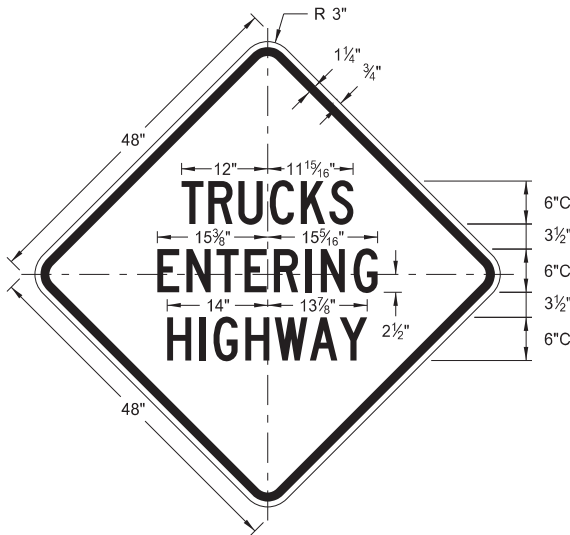


W8-53-48

Legend: black (non-refl)
Background: orange

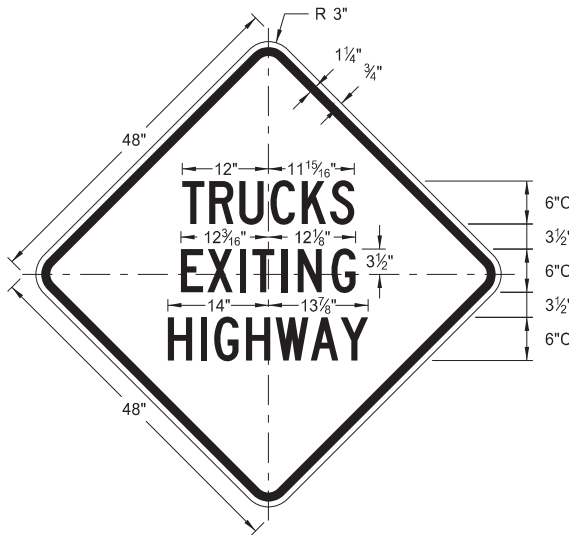


W8-56-48

Legend: black (non-refl)
Background: orange

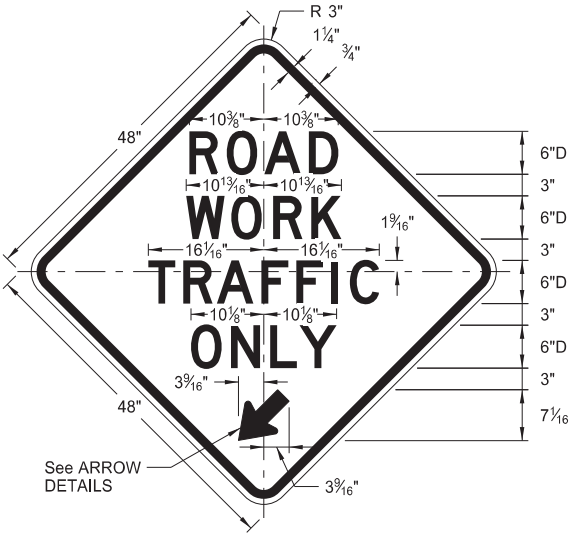


W5-9-48

Legend: black (non-refl)
Background: orange

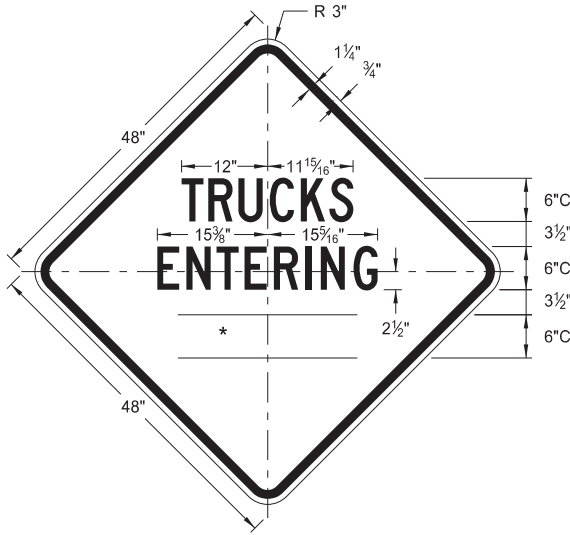


W8-54-48

Legend: black (non-refl)
Background: orange

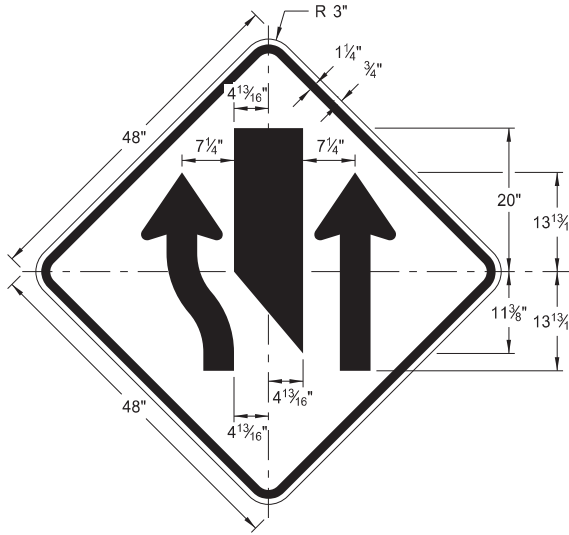


W9-3a-48

Legend: black (non-refl)
Background: orange

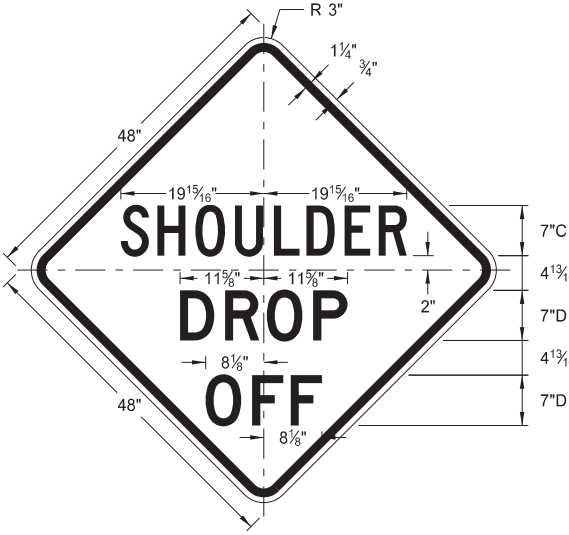

W8-9a-48

Legend: black (non-refl)
Background: orange


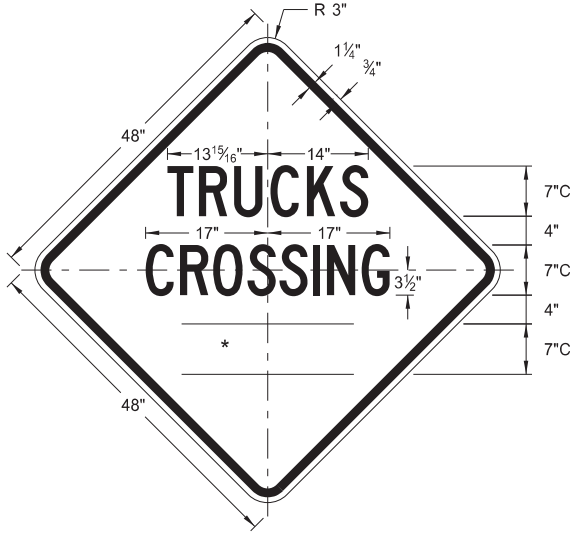


W8-55-48

Legend: black (non-refl)
Background: orange

WORD	LETTER SPACING
AHEAD	Standard
200 FT	Standard
350 FT	Standard
500 FT	Standard
1000 FT	Reduce 40%
1500 FT	Reduce 40%
1/2 MILE	Reduce 50%
1 MILE	Standard

* DISTANCE MESSAGES

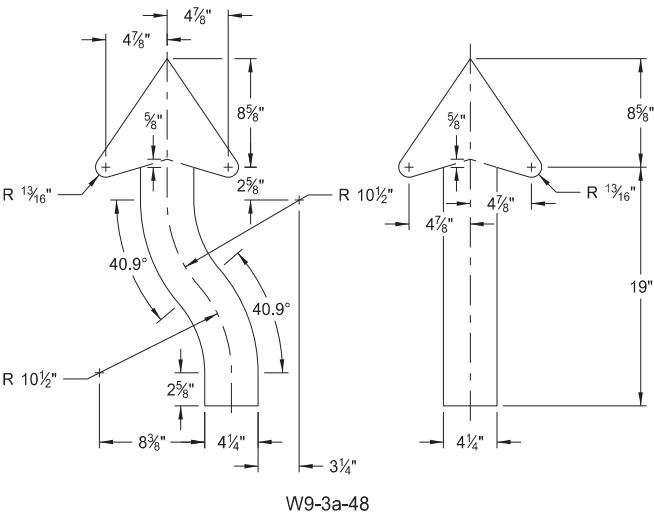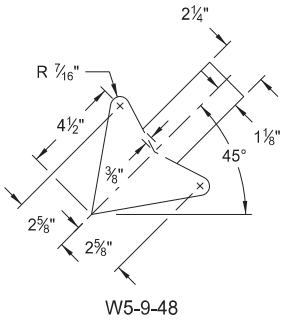


ARROW DETAILS

NORTH DAKOTA DEPARTMENT OF TRANSPORTATION	
8-13-13	
REVISIONS	
DATE	CHANGE
8-17-17	Updated sign number
5-31-18	Revised sign and arrow details
10-03-19	New Design Engineer PE Stamp

This document was originally
issued and sealed by
Kirk J Hoff,
Registration Number
PE- 4683,
on 10/03/19 and the original
document is stored at the
North Dakota Department
of Transportation

BARRICADE AND CHANNELIZING DEVICE DETAILS

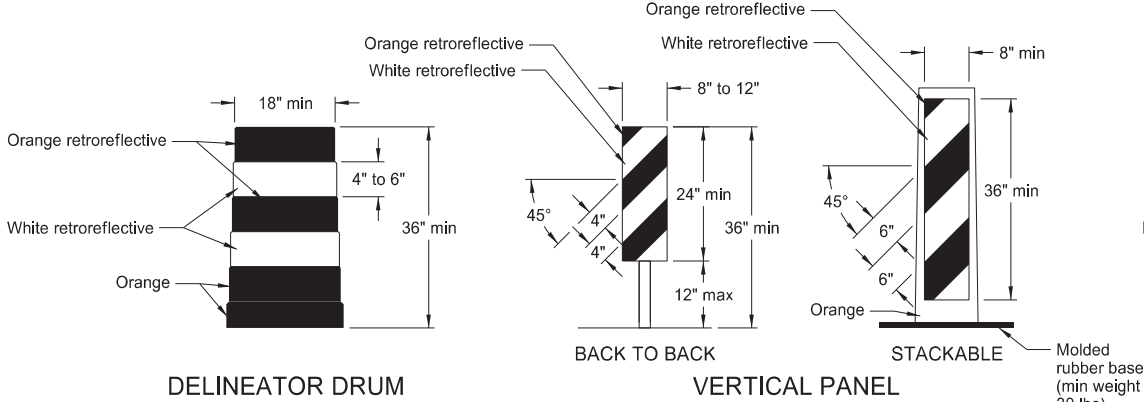

DELINEATOR DRUM


Provide horizontal, circumferential, alternating orange and white retroreflective stripes 4" to 6" wide for drum markings. Use a minimum of two orange and two white stripes with the top stripe being orange for each drum. Do not exceed 3" nonretroreflectORIZED spaces between the horizontal orange and white stripes. Avoid placement of stripes on drum ribs or indentations. Use closed top drums that will not allow collection of debris. Do not place ballast on the top of drum.

VERTICAL PANEL

Provide alternating orange and white retroreflective stripes, sloping downward in direction vehicular traffic is to pass. Place retroreflective sheeting on both sides of panel with a minimum of 270 square inches of retroreflective area facing vehicular traffic. Where the height of the retroreflective material on the vertical panel is 36 inches or more, use a stripe width of 6 inches.


STACKABLE

Molded rubber base (min weight 30 lbs)

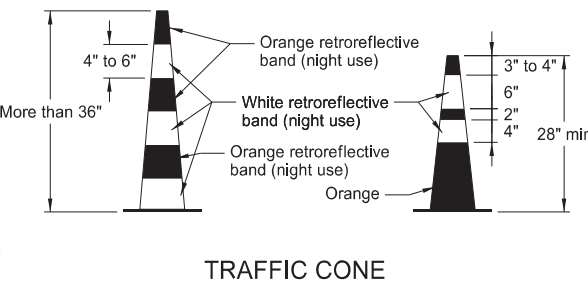


TRAFFIC CONE

Provide retroreflectORIZATION of cones more than 36" in height by alternating orange and white retroreflective stripes. Use a minimum of two orange and two white stripes for each cone with the top stripe being orange. Use maximum 3" nonretroreflectORIZED space between the orange and white stripes.

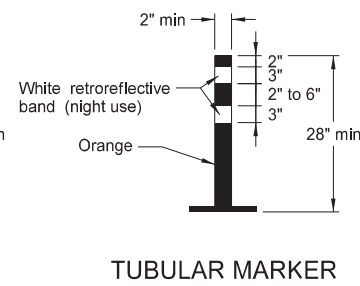

TUBULAR MARKER


Provide retroreflectORIZATION of tubular markers more than 42" in height by alternating four 4" to 6" wide orange and white stripes with the top stripe being orange.

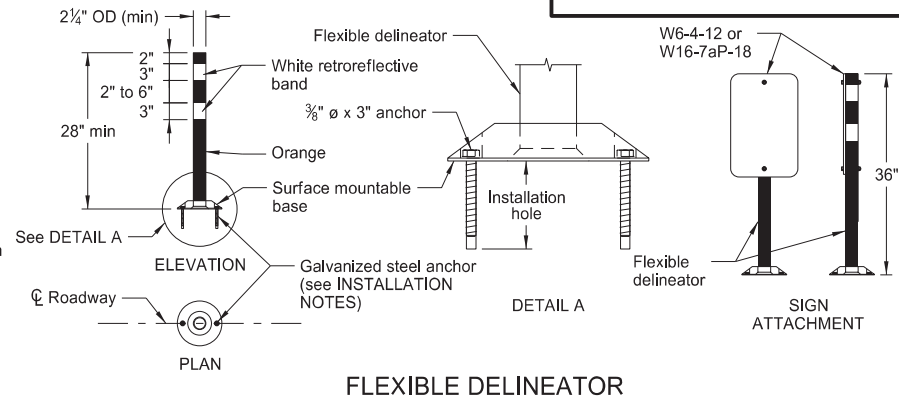

FLEXIBLE DELINEATOR

INSTALLATION NOTES:

1. Drill installation holes to diameter and depth required by manufacturer's specifications.
2. For removal, remove anchors and fill installation hole with an epoxy designed to bond to pavement surface.
3. In lieu of bolted down base, use an 8" x 8" butyl pad or hot melt butyl. Remove butyl as close as possible to pavement surface.

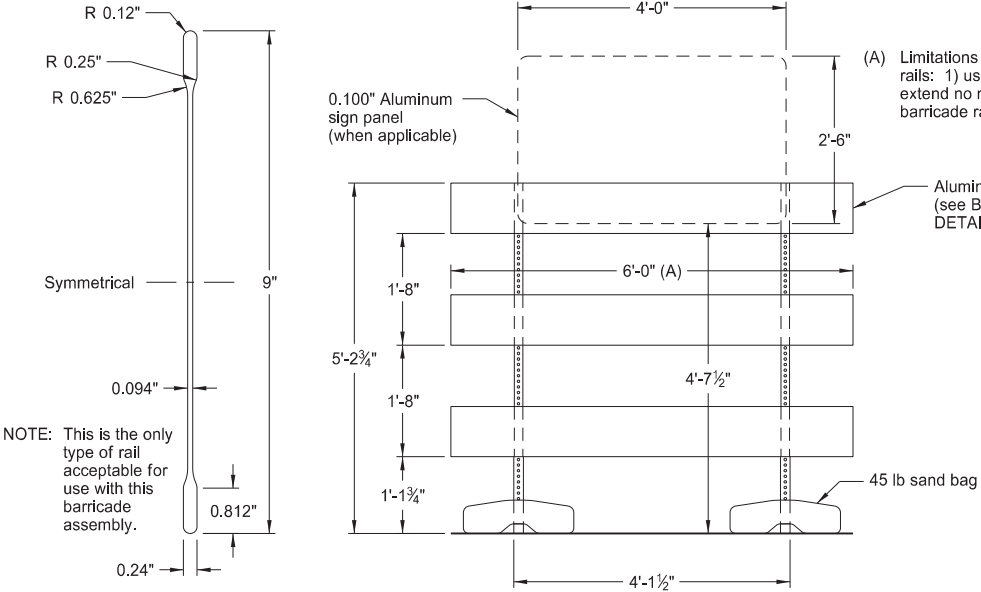


BARRICADE BLADE DETAIL

ELEVATION VIEW

BARRICADE ASSEMBLY DETAIL (Aluminum Barricade Rails)



NOTE: For barricade markings use alternating orange and white retroreflective stripes, sloping downward in the direction traffic is to pass. Place retroreflective sheeting on both sides of the rails with a minimum of 270 square inches of visible retroreflective area facing vehicular traffic. When the barricade length is less than 36", use a rail stripe width of 4".

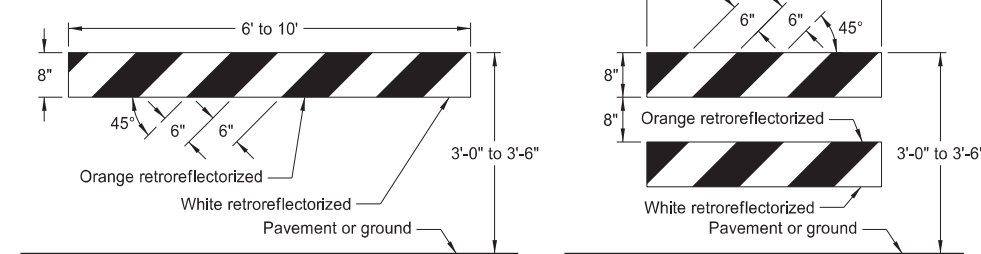


TYPE I BARRICADE

TYPE II BARRICADE

BARRICADE RAIL DETAILS

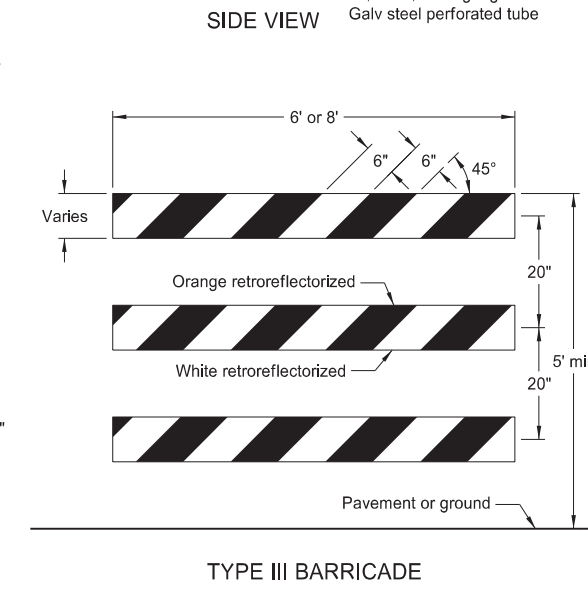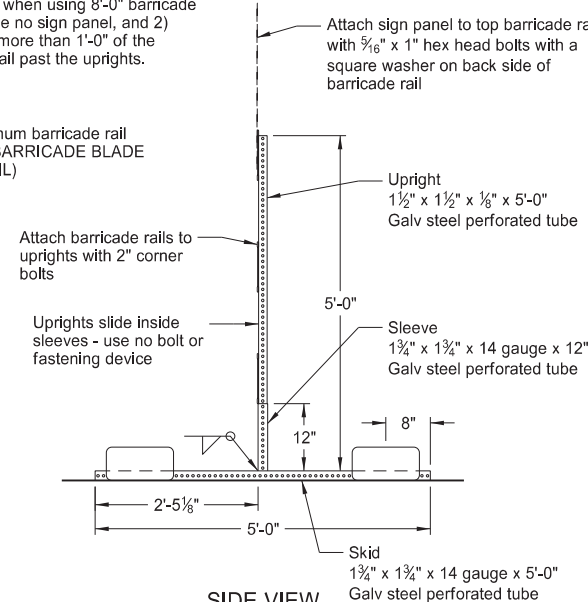

TYPE III BARRICADE

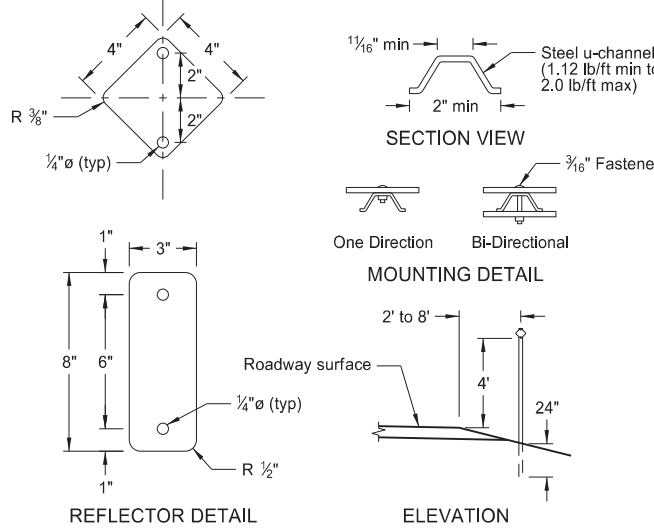

REFLECTOR DETAIL

ELEVATION

DELINEATORS

MINIMUM BALLAST
(For each side of barricade support)

Without Sign	4 - 25 lb sandbags
With Sign	6 - 25 lb sandbags


NOTE: Number of sandbags based on a wind speed of 55 MPH. Sandbags assumed to be placed at or near the ends of the skids.

NORTH DAKOTA DEPARTMENT OF TRANSPORTATION	
10-3-13	
REVISIONS	
DATE	CHANGE
9-27-17 11-01-19	Updated to active voice Revised details for Flexible Delineator




This document was originally issued and sealed by
Kirk J Hoff,
Registration Number
PE-4683,
on 11/1/19 and the original document is stored at the
North Dakota Department
of Transportation

CONSTRUCTION SIGN PUNCHING AND MOUNTING DETAILS


Note: In curb sections, place signs a minimum horizontal distance of 2' from face of the curb to near edge of the sign.

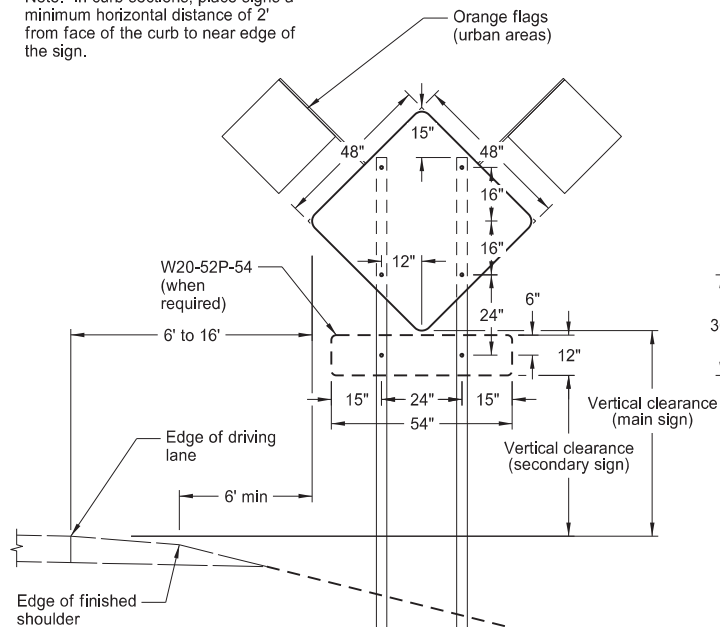


TYPICAL SECTION
(48" x 48" diamond warning sign shown)

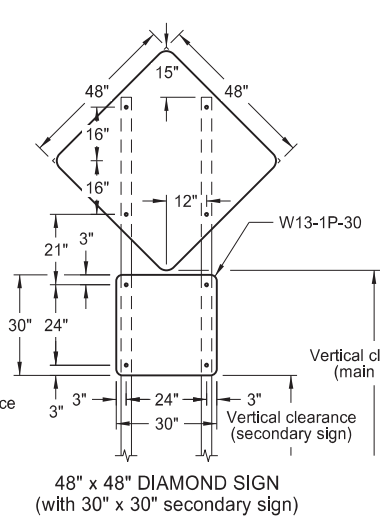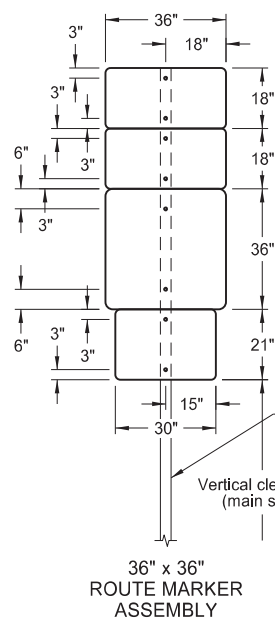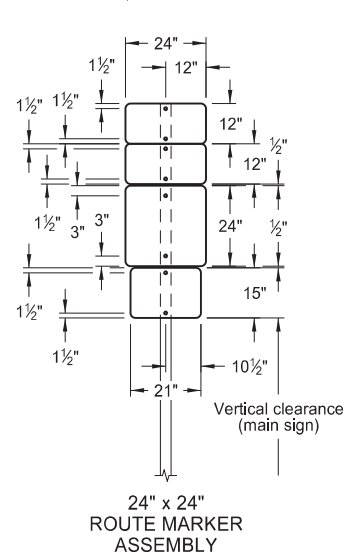


R1-2-60 - YIELD SIGN

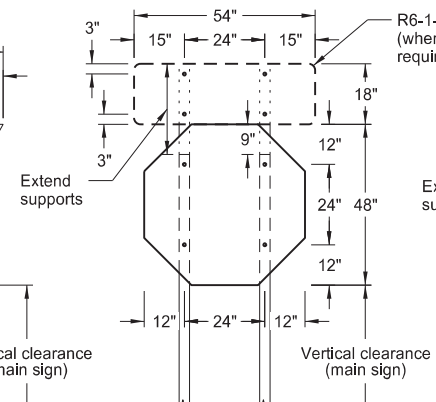


R1-1-48 - STOP SIGN
(with R6-1-54 sign as required)

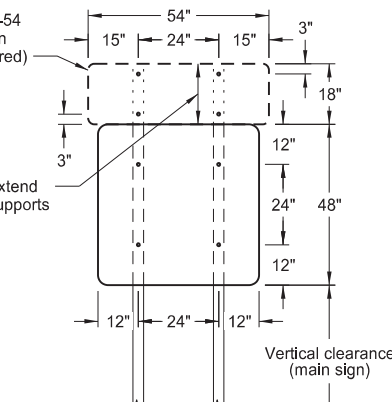


48" x 48" SIGN
(with R6-1-54 sign as required)

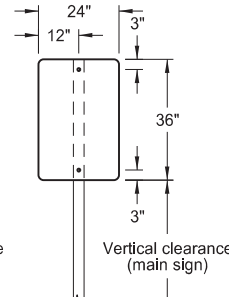


24" x 36" SIGN

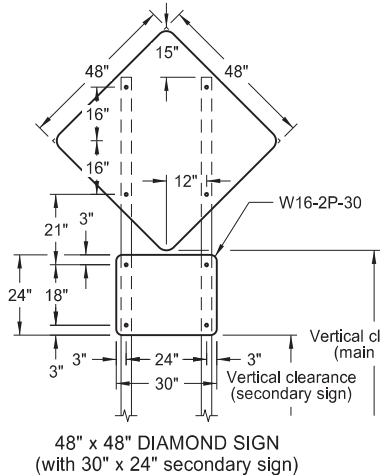


48" x 48" DIAMOND SIGN
(with 30" x 24" secondary sign)

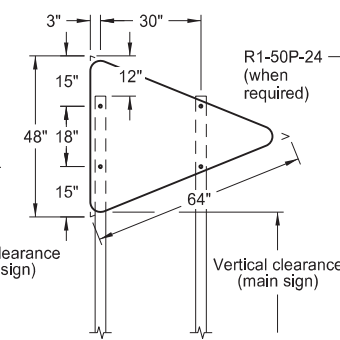


W14-3-64 - PENNANT SIGN

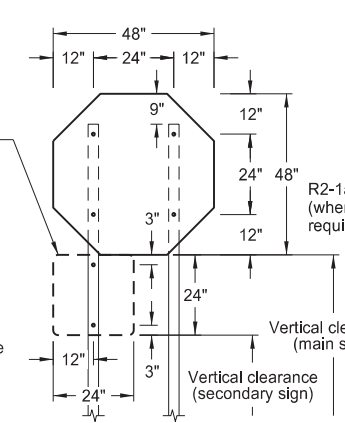


R1-1-48 - STOP SIGN
(with R1-50P-24 sign as required)

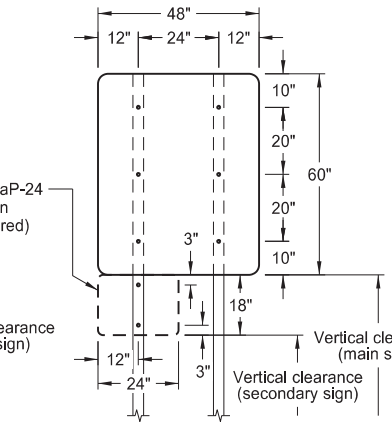


48" x 48" SIGN
(with R2-1aP-24 sign as required)

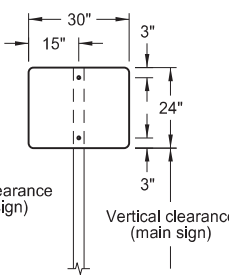


30" x 24" SIGN

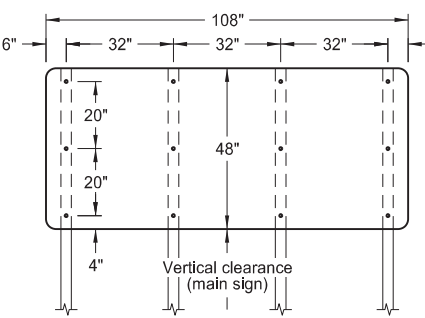


108" x 48" SIGN

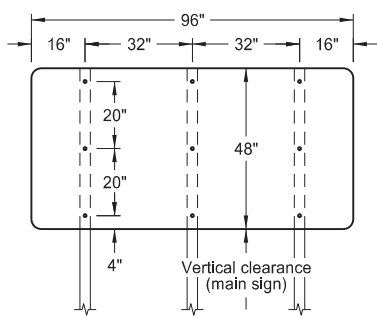


96" x 48" SIGN

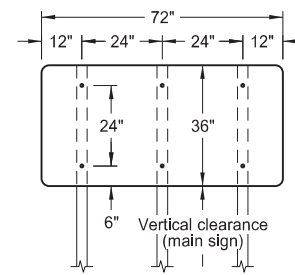


72" x 36" SIGN

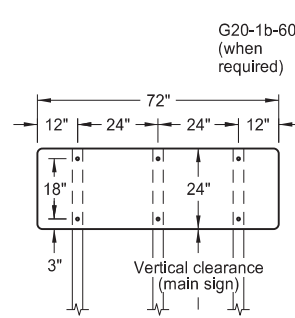


72" x 24" SIGN

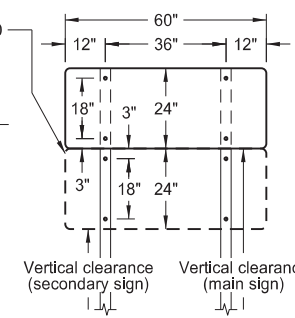


60" x 24" SIGN

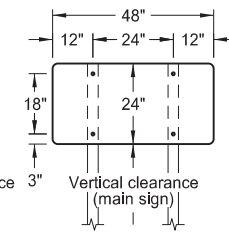

48" x 24" SIGN

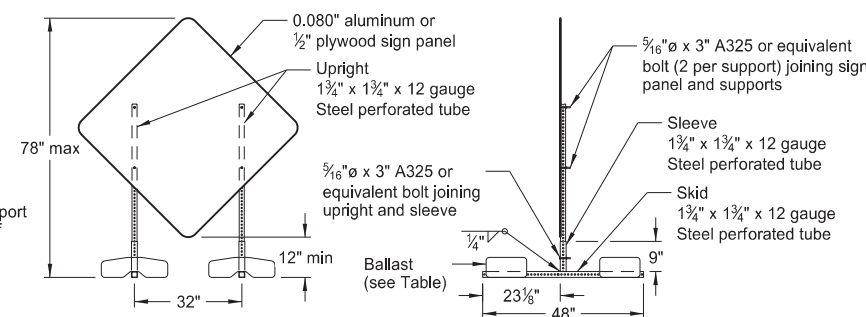

PORTABLE SIGN SUPPORT
LOW-MOUNTING HEIGHT

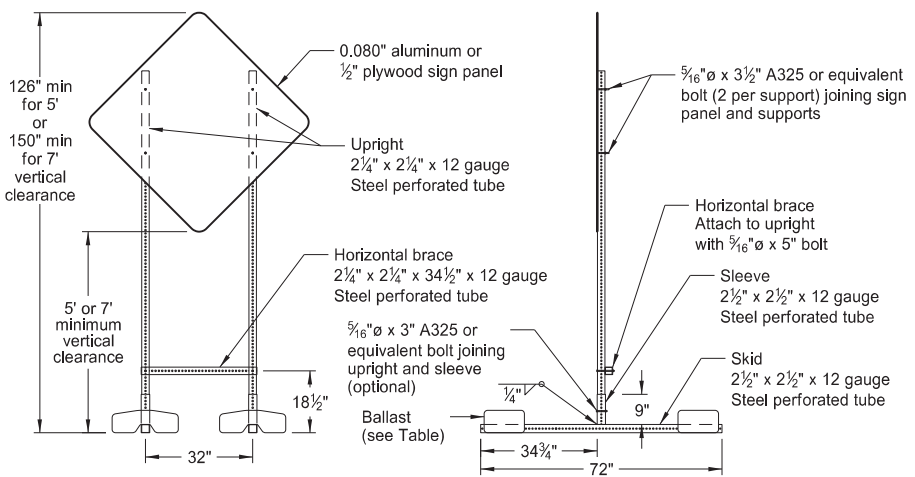

PORTABLE SIGN SUPPORT
HIGH-MOUNTING HEIGHT

NOTES:

1. Sign Supports: Galvanize or paint supports. Minimum post sizes are 2.5 lb/ft u-channel or 2" x 2" x 12 gauge steel perforated tube, except where noted. When installing signs on u-channel, minimum post size for assemblies containing a secondary sign is 3.0 lb/ft. Post sizes based on a wind speed of 55 MPH.

Place signs over 50 square feet on 2½" x 2½" perforated tube supports as a minimum.

Do not attach guy wires to sign supports. Attach wind beams behind sign panels when used with u-posts.
2. Sign Panels: Provide sign panels made of 0.100" aluminum, ½" plywood, or other approved material, except where noted. Punch all holes round for ⅝" bolts.
3. Alternate Messages: Install and remove alternate message signs on reflectorized plate (without borders) as required. (i.e. "Left" and "Right" message on lane closure sign)
4. Route Marker Auxiliary Signs: Provide route marker auxiliary signs, such as the cardinal direction and directional arrows, with a background and legend that match the route marker they are used with:

Interstate - white legend on blue background
Interstate Business Loop - white legend on green background
US and State - black legend on white background
County - yellow legend on blue background

5. Vertical Clearance: Install signs with a vertical clearance of 5'-0" (see TYPICAL SECTION). In areas where parking or pedestrian movements are likely or the view of the sign may be obstructed, install signs with a vertical clearance of 7'-0" from the top of the curb or from the near edge of the driving lane in absence of a curb.

The vertical clearance to secondary signs is 1'-0" less than the vertical clearance stated above.

Provide a minimum clearance of 7'-0" from the ground at the post for signs with an area exceeding 50 square feet.

6. Portable Signs: Provide portable signs that meet the vertical clearance stated above when it is necessary to place signs within the pavement surface.

Use of low-mounting height (minimum 12" vertical clearance) portable signs for 5 days or less, is allowed as long as the view of the sign is not obstructed. Time delays caused by unforeseen circumstances, such as equipment breakdown, rain, subgrade failures, etc., will not accrue towards the 5 day period. Use of R9-8 through R9-11a series, W1-6 through W1-8 series, M4-10, and E5-1 is allowed for longer than 5 days.

Restrict signs mounted on portable sign supports shown in the LOW-MOUNTING HEIGHT and HIGH-MOUNTING HEIGHT details to a maximum surface area of 16 square feet.

MINIMUM BALLAST
(For each side of sign support base)

Sign Panel Mounting Height (ft)	Number of 25 lb sandbags for 4' x 4' sign panel
1'	6
5'	8
7'	10

Note: The number of sandbags are based on a wind speed of 55 MPH. Place sandbags at or near the ends of skids.

NORTH DAKOTA DEPARTMENT OF TRANSPORTATION	
10-4-13	
REVISIONS	
DATE	CHANGE
11-14-13	Revised Note 6
9-27-17	Updated to active voice
11-01-19	Revised 60"x24" sign detail

This document was originally issued and sealed by

Kirk J Hoff,
Registration Number
PE-4683,
on 11/1/19 and the original document is stored at the North Dakota Department of Transportation

CONSTRUCTION TRUCK AND TEMPORARY DETOUR LAYOUTS

D-704-22






KEY

Type III
barricade

Sign

Work area

Flagger

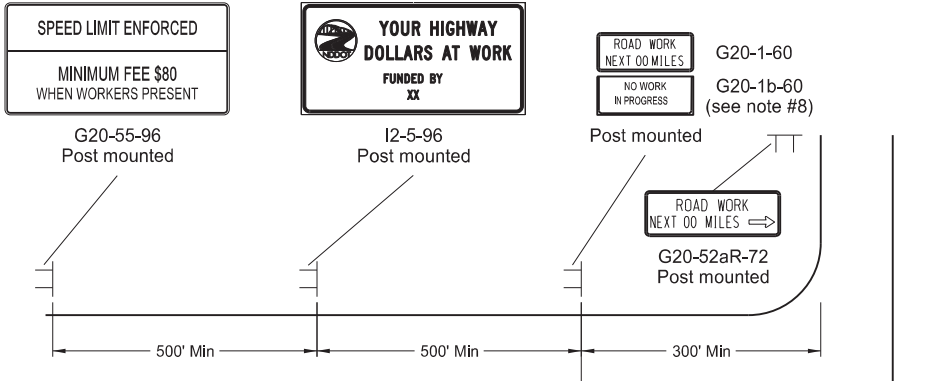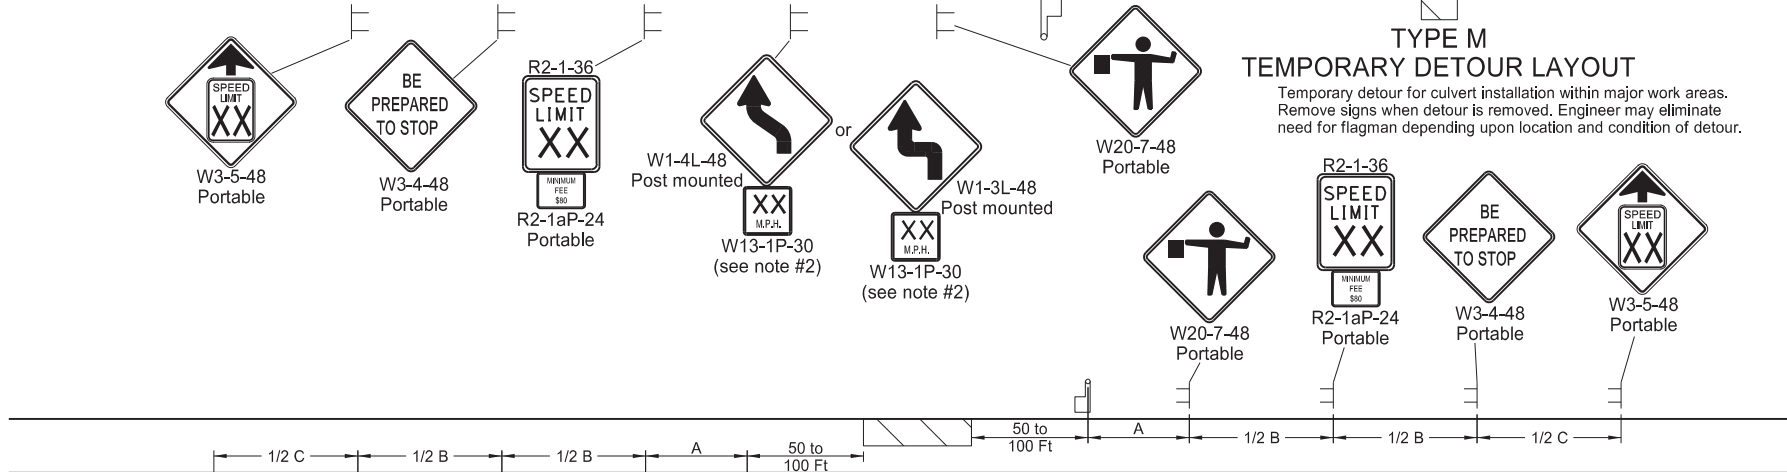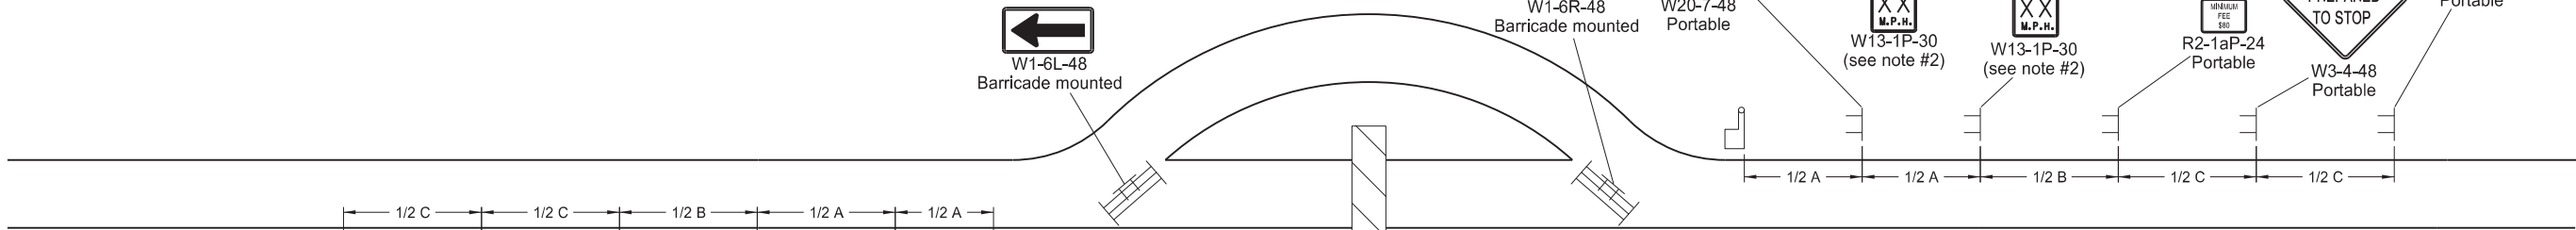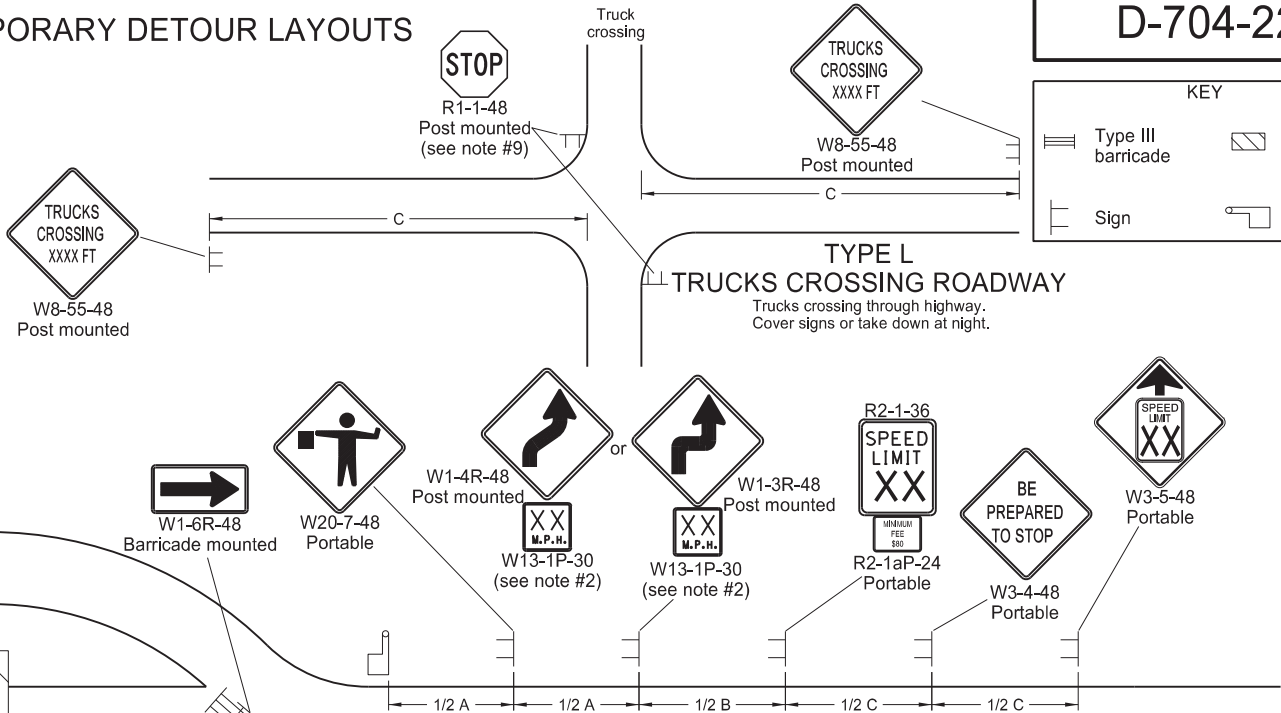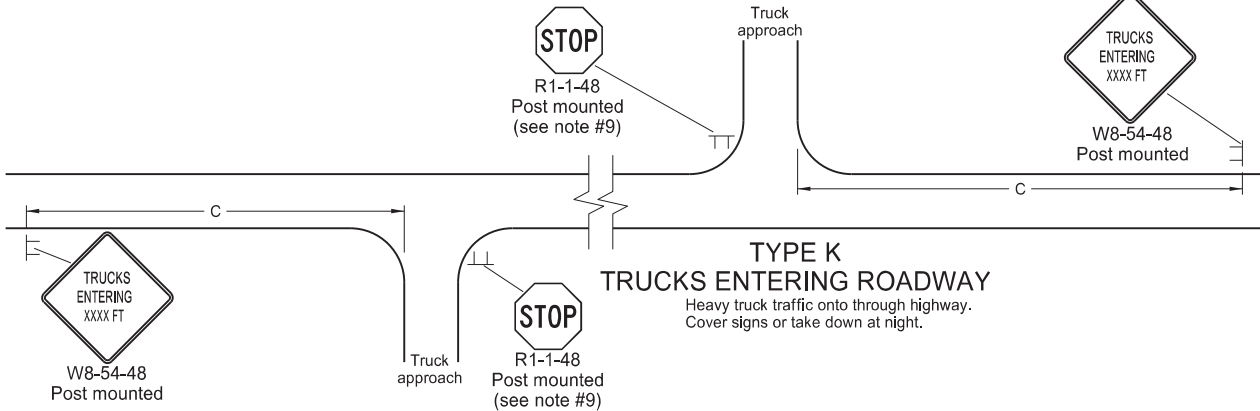

- Notes:
- Place barricades on a moveable assemblies and signs on portable assemblies when located on roadway.
 - Where necessary, safe speed to be determined by the Engineer.
 - Determine the reduced speed limit based on the in-place speed limit before construction. Where speed reductions exceed 30 mph, install a second speed limit sign with the desired speed reduction (not to exceed 30 mph.) Place the second speed limit sign at 1/2 B.
 - Install flags on warning signs in urban areas when signs are not portable. Mount 24 inch square flags perpendicular to the edges of the sign, and at such a distance above the edge that the flag does not touch the sign when limp.
 - Cover existing speed limit signs within a reduced speed zone.
 - Covered (when approved by engineer) or obliterated pavement marking measured as Obliteration of Pavement Marking.
 - As an option, use portable sign supports in lieu of post mounted signs in accordance with NDDOT Standard Drawing D-704-14.
 - Install sign G20-1b-60 when work is suspended for winter.
 - If existing stop sign is in place, a 48" stop sign is not required.
 - Sign G20-55-96 is not required if layout is part of other traffic control that contains this sign, or if work is less than 15 days.
 - Recommend using 40 mph speed limit in vicinity of workers, unless location and conditions dictate otherwise.
 - Sign I2-5-96 is not required if layout is part of other traffic control that contains this sign.



ADVANCE WARNING SIGN SPACING			
Road Type	Distance Between Signs Min. (ft)		
	A	B	C
Urban - Low Speed (30 mph or less)	150	150	150
Urban - Low Speed (over 30 to 40mph)	280	280	280
Urban - High Speed (over 40 mph to 50 mph)	360	360	360
Rural - High Speed (over 50 mph to 65 mph)	720	720	720
Urban Expressway and Freeway (55 mph to 60 mph)	850	1350	2200
Rural Expressway and Freeway (70 mph to 75 mph)	1000	1500	2640
Interstate/4-Lane Divided (Maintenance and Surveying)	750	1000	1500

NORTH DAKOTA DEPARTMENT OF TRANSPORTATION	
9-27-13	
REVISIONS	
DATE	CHANGE
06-17-17 11-01-19 12-09-21	Update notes & sign numbers Revised sign numbers & note 7 Added Speed Limit Enforced and Dollars At Work signs


This document was originally issued and sealed by
Kirk J Hoff,
Registration Number
PE-4683,
on 12/09/21 and the original document is stored at the
North Dakota Department
of Transportation

MOBILE OPERATION
(PAVEMENT MARKING)


D-704-27

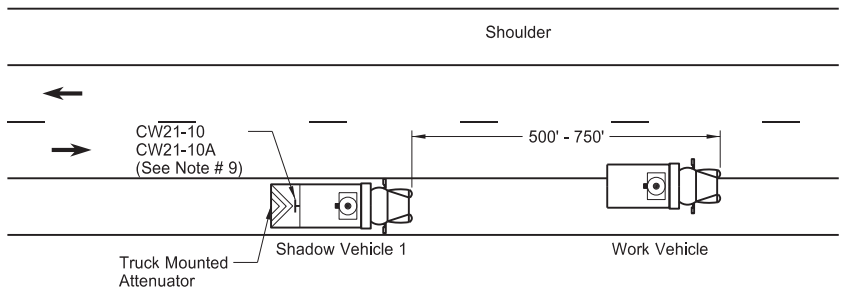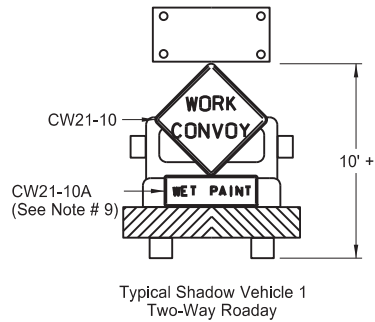


Two-Way Roadway with Paved Shoulders

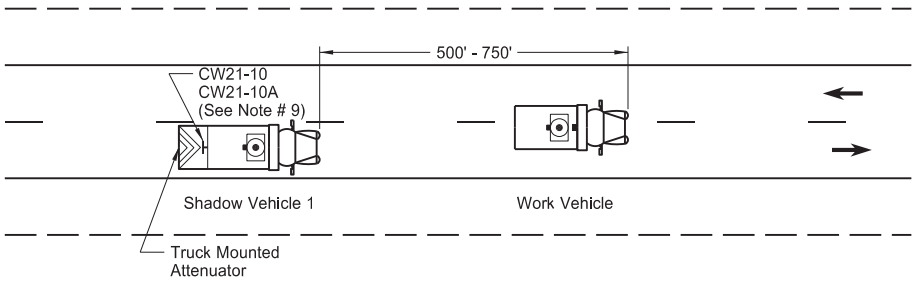


Two-Way Roadway without Paved Shoulders

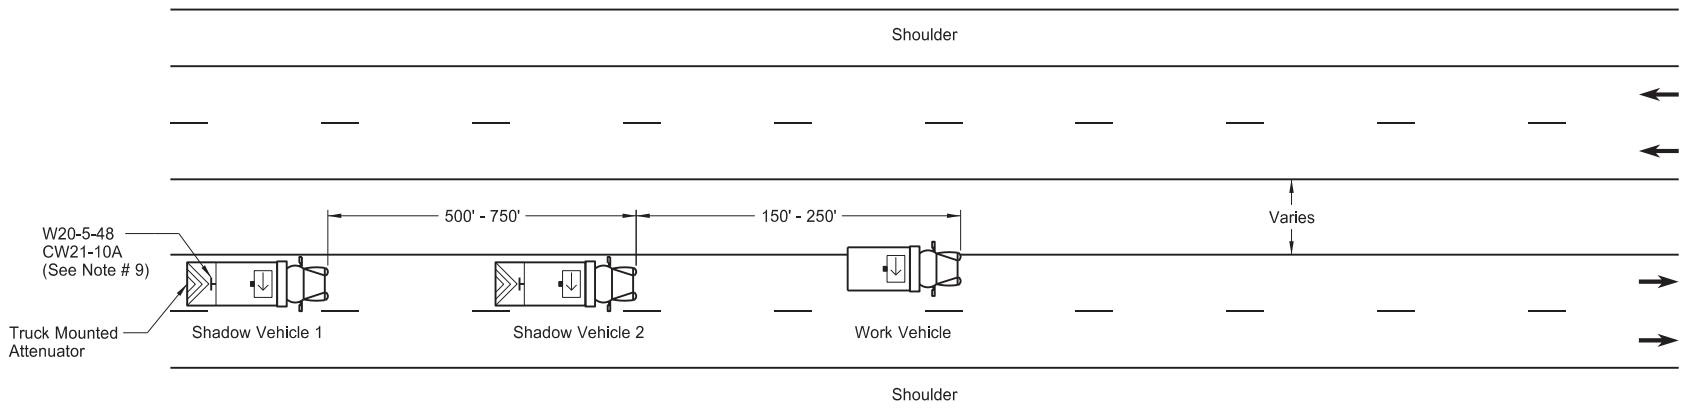

Undivided Multi-Lane Roadway

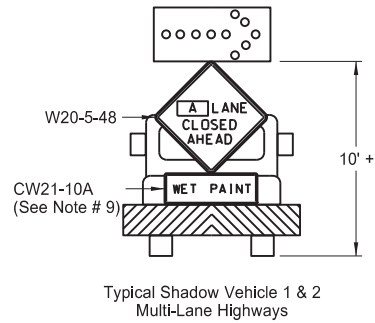


A = Left Right Center

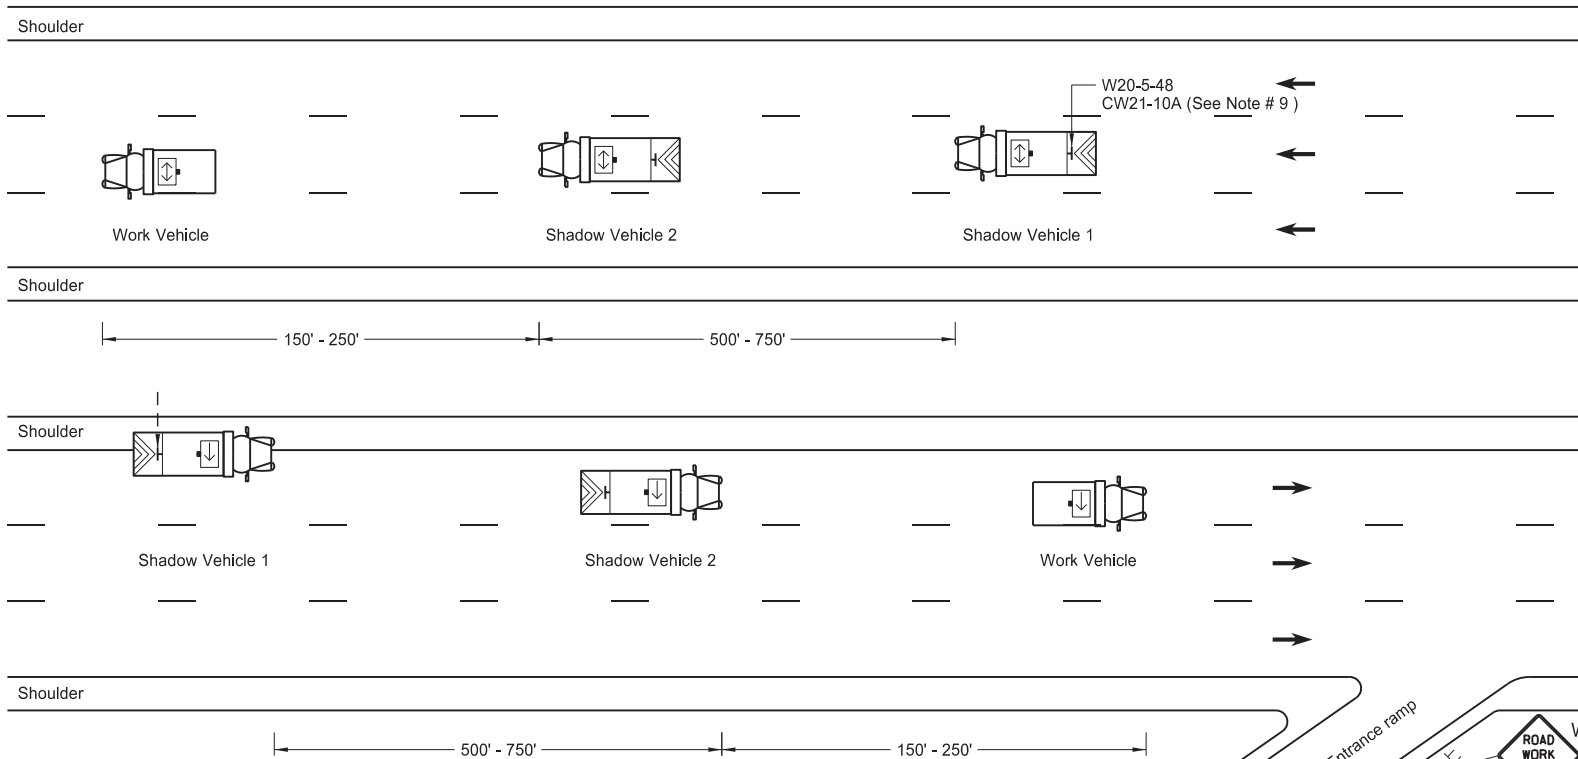


Divided Multi-Lane Highway

Sign Details

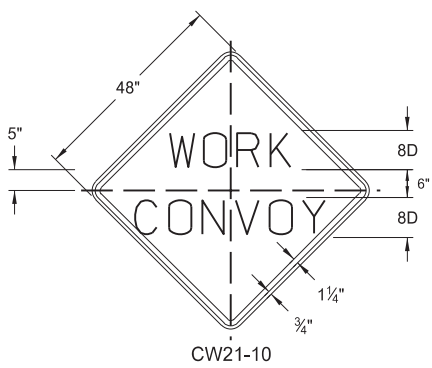

CW21-10

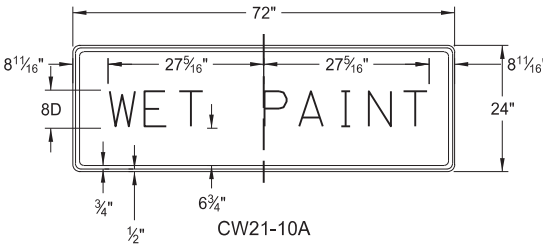

CW21-10A


- Notes
1. Use additional vehicles you choose to be in the convoy with truck mounted attenuators, at your own expense.
 2. Display yellow rotating beacons or strobe lights on shadow and work vehicles, unless otherwise stated in the plans.
 3. Use Type B or Type C flashing arrow panels controlled from inside the vehicle.
 4. Provide each vehicle with two-way electronic communication capability.
 5. Move shadow vehicle 1 first to shadow other convoy vehicles when convoy changes lane.
 6. Vary vehicle spacing between shadow vehicle 1 and shadow vehicle 2 based on sight distance restrictions. Motorists approaching the work convoy need to see trail vehicle in time to slow down and/or change lanes as they approach shadow vehicle.
 7. Sign Colors
Letters = Black
Border = Black
Background = Orange
 8. As an option, use shadow vehicle 2 the paint tender vehicle.
 9. Use sign CW21-10A only during painting operation.
 10. Pull over work and shadow vehicles periodically to allow motor vehicle traffic to pass on two lane - two way roadways.

KEY


- Sign
- Truck mounted attenuator
- Flashing arrow panels:
- Right directional
 - Left directional
 - Double arrow directional
 - Caution Mode

NORTH DAKOTA DEPARTMENT OF TRANSPORTATION	
9-27-13	
REVISIONS	
DATE	CHANGE
6-18-14	Removed shadow vehicle 2 on two lane roadways
9-27-17	Updated to active voice
11-08-19	Changed Standard Heading

This document was originally issued and sealed by
Kirk J Hoff,
Registration Number
PE- 4683,
on 11/08/19 and the original document is stored at the
North Dakota Department
of Transportation

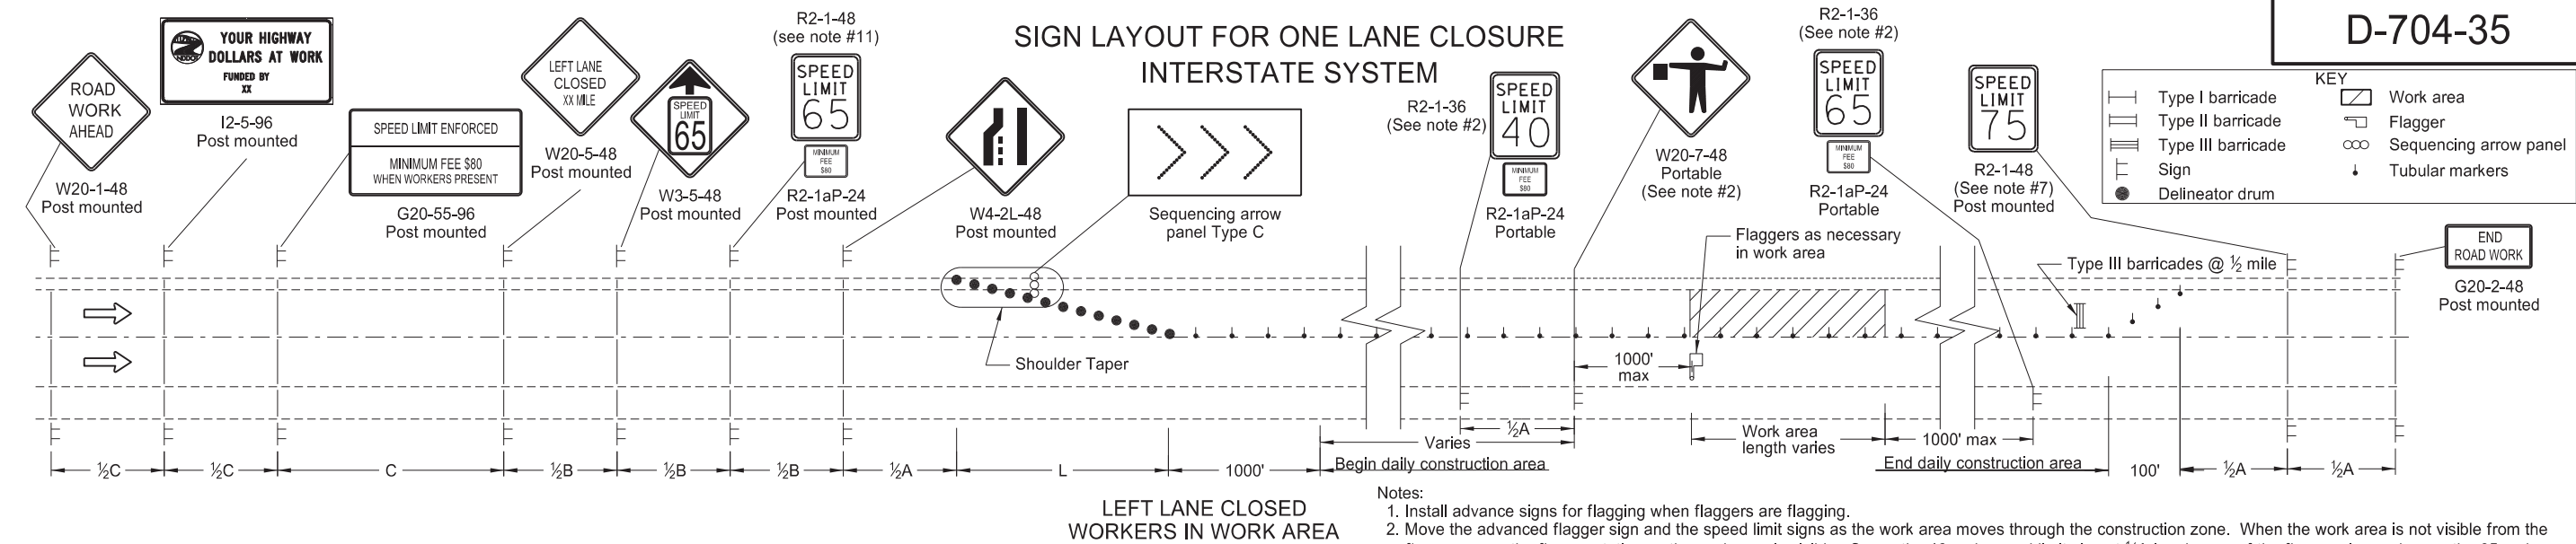

ADVANCE WARNING SIGN SPACING			
Road Type	Distance Between Signs Min. (ft)		
	A	B	C
Rural - High Speed (over 50 mph to 65 mph)	720	720	720
Urban Expressway and Freeway (55 mph to 60 mph)	850	1350	2200
Rural Expressway and Freeway (70 mph to 75 mph)	1000	1500	2640
Interstate/4-Lane Divided (Maintenance and Surveying)	750	1000	1500

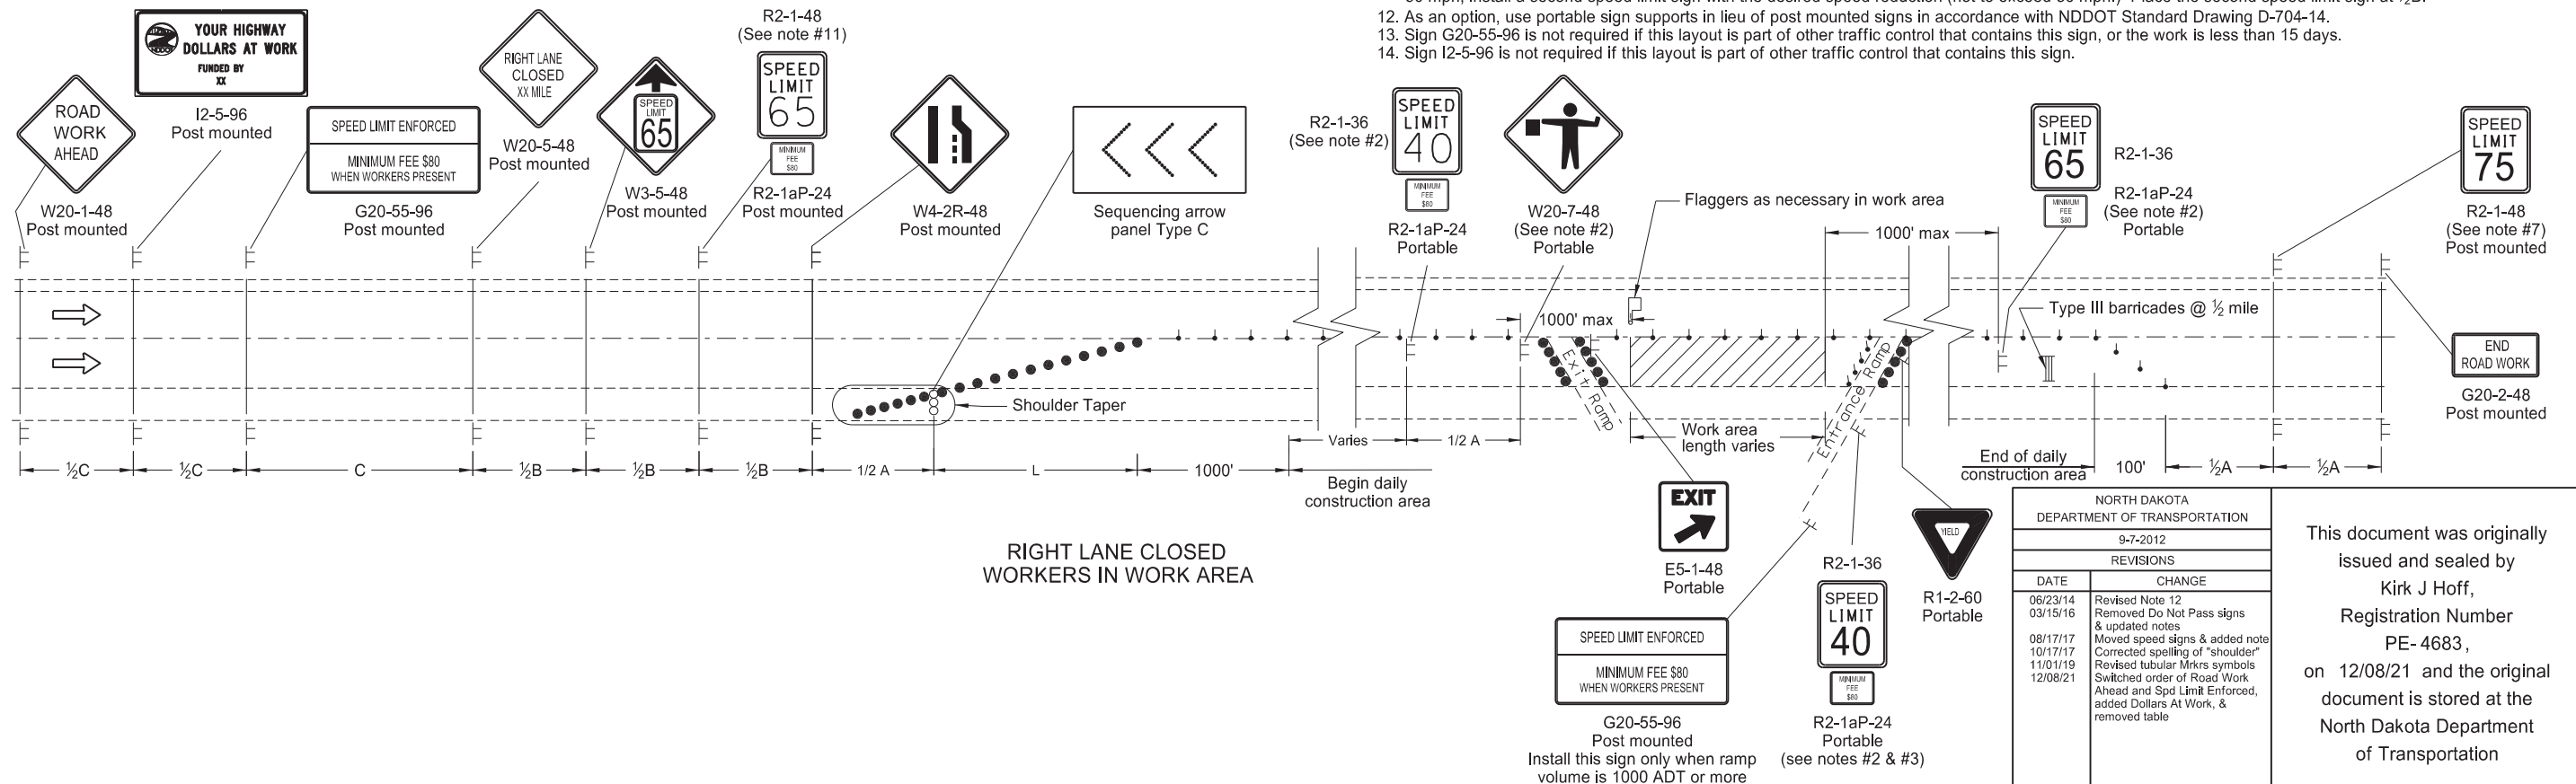


NORTH DAKOTA DEPARTMENT OF TRANSPORTATION	
9-7-2012	
REVISIONS	
DATE	CHANGE
06/23/14	Revised Note 12
03/15/16	Removed Do Not Pass signs & updated notes
08/17/17	Moved speed signs & added note
10/17/17	Corrected spelling of "shoulder"
11/01/19	Revised tubular Mtrks symbols
12/08/21	Switched order of Road Work Ahead and Spd Limit Enforced, added Dollars At Work, & removed table

This document was originally issued and sealed by
Kirk J Hoff,
Registration Number
PE-4683,
on 12/08/21 and the original document is stored at the
North Dakota Department
of Transportation

PORTABLE SIGN SUPPORT ASSEMBLY

D-704-50

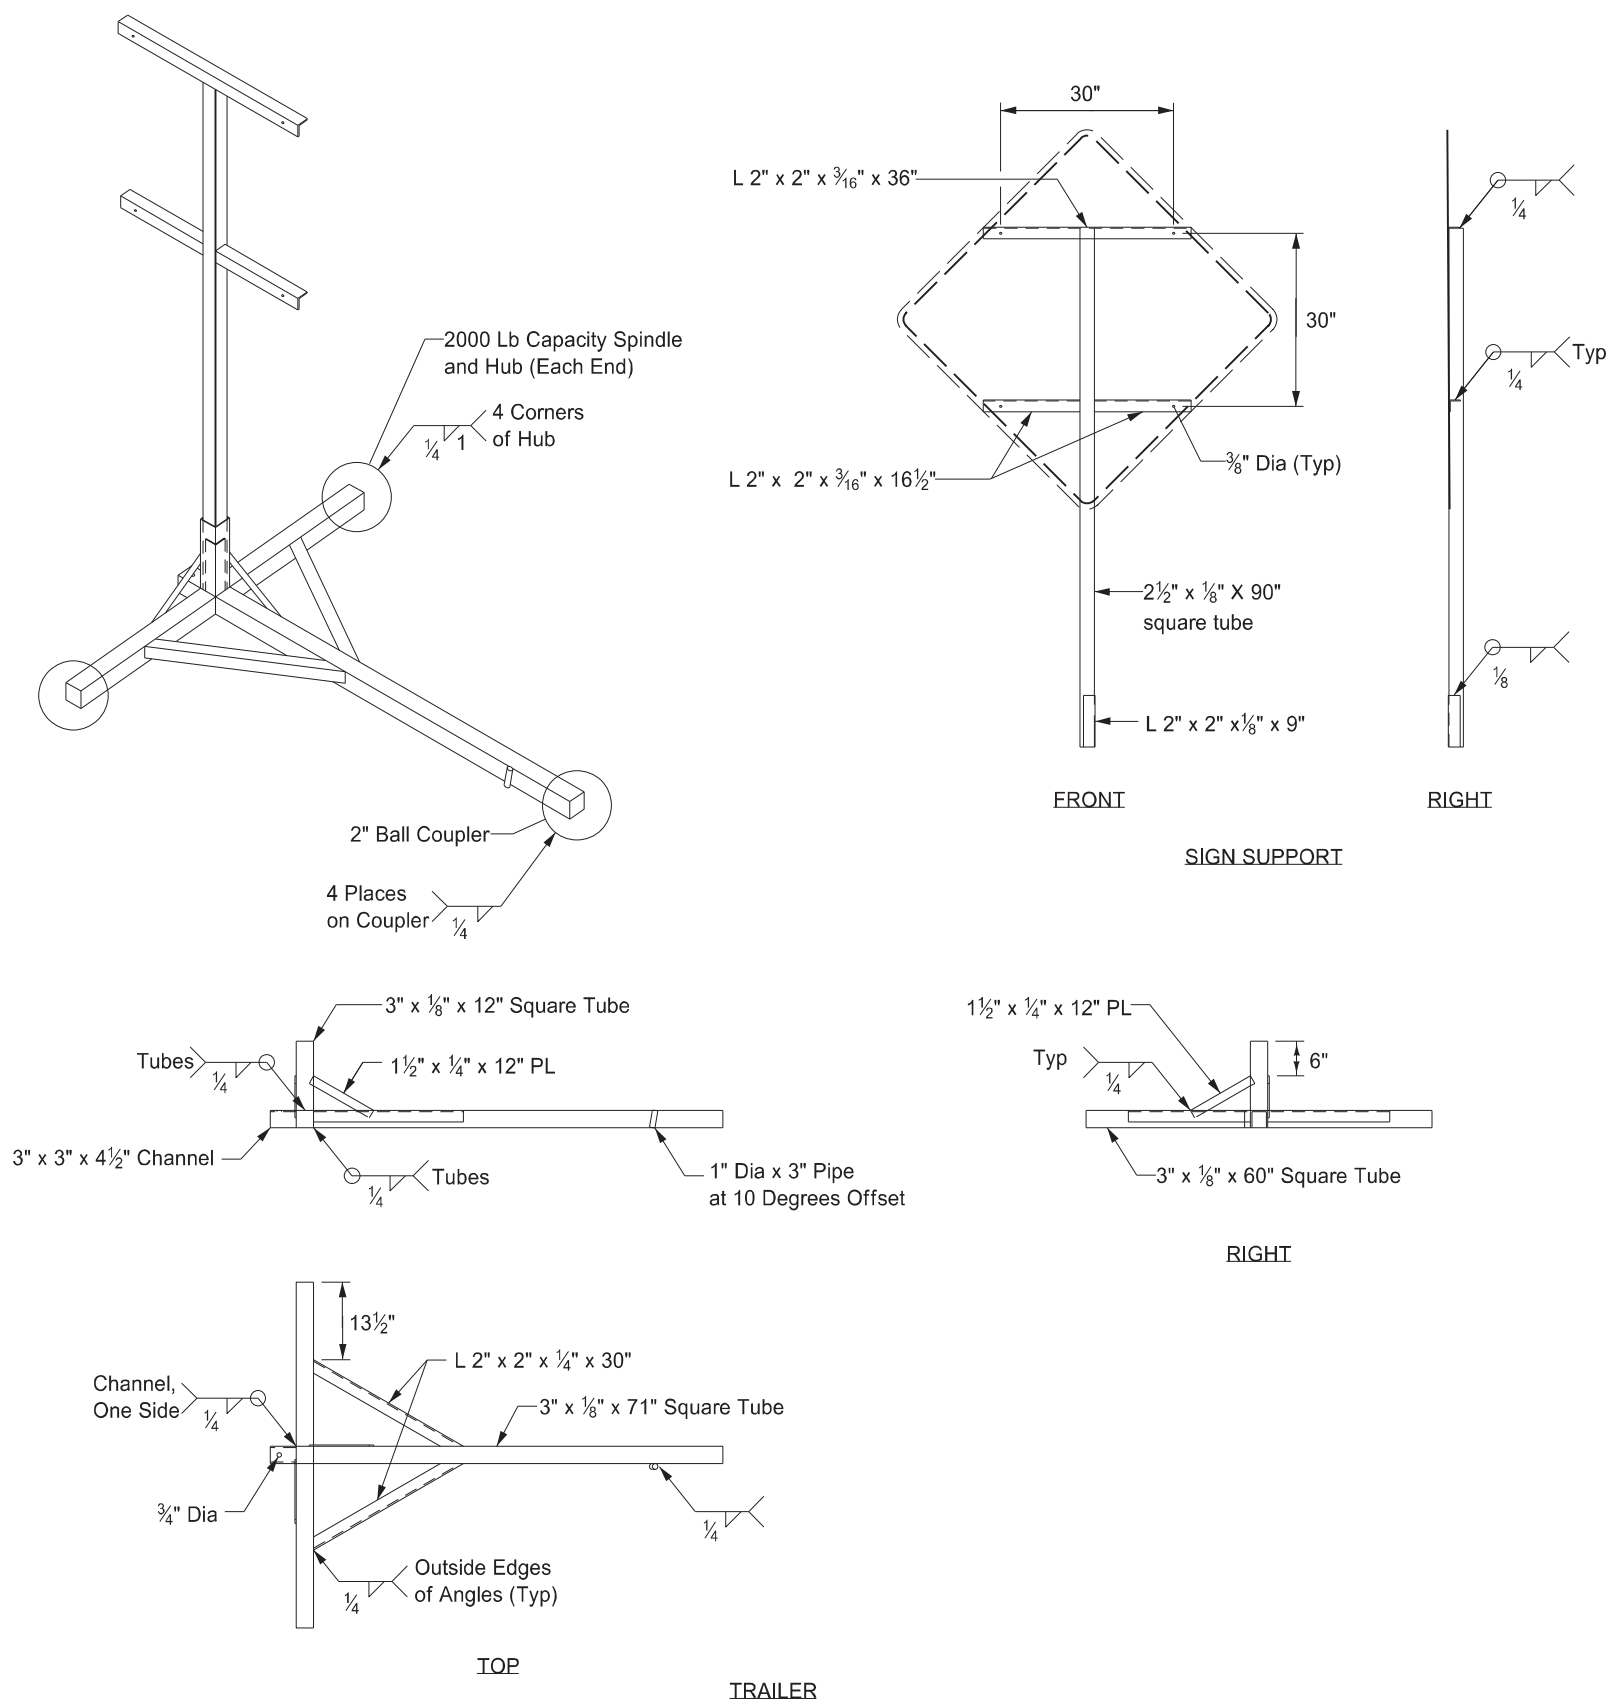


- Notes:
- 1. Maximum 250 pound weight of assembly.
 - 2. Use a 14" wheel and tire.
 - 3. Use no automotive and equipment axle assemblies for trailer-mounted sign supports.
 - 4. Other NCHRP 350 or MASH crash tested assemblies are acceptable.

NORTH DAKOTA DEPARTMENT OF TRANSPORTATION	
11-23-10	
REVISIONS	
DATE	CHANGE
12/02/2020	Updated Note to active voice.



INTERSTATE PAVEMENT MARKING
4 LANE DIVIDED HIGHWAY

D-762-2

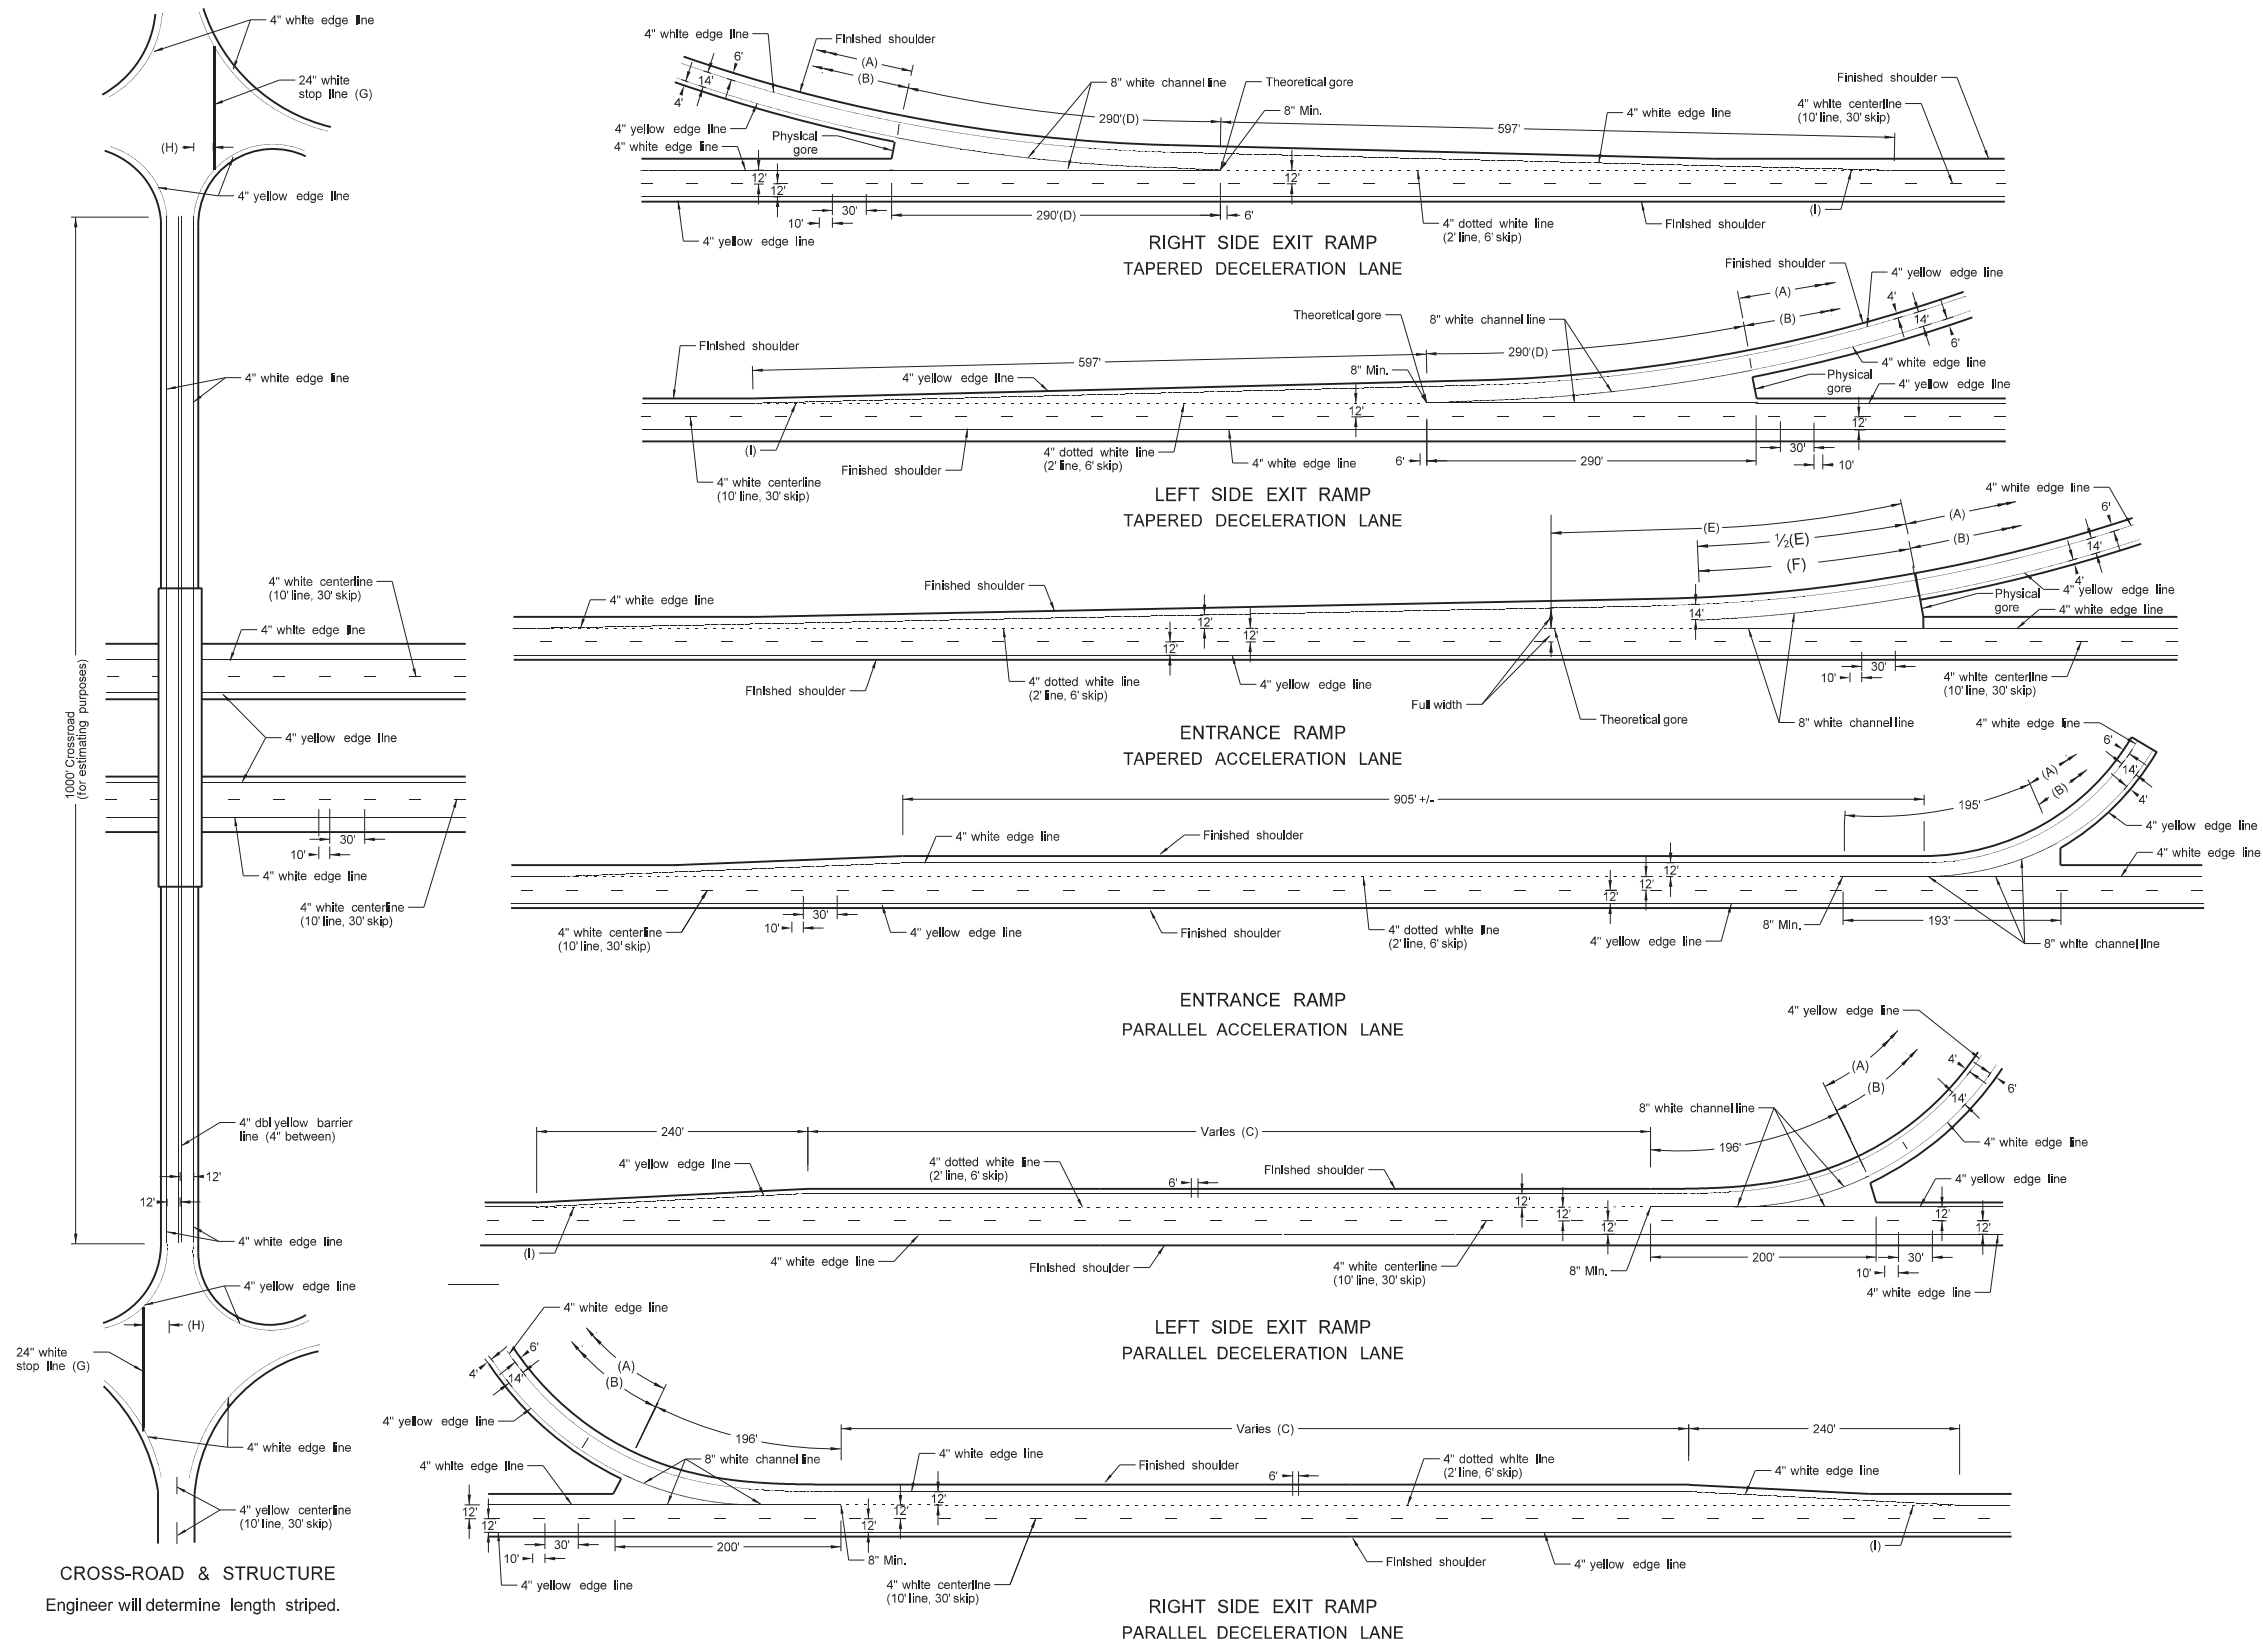















- NOTE:
- (A) 4" White edge line
 - (B) 4" Yellow edge line
 - (C) Assume "varies" equals 790' for purpose of estimate. Place pavement marking from beginning of taper to the 8" line.
 - (D) Beginning of physical gore to theoretical gore.
 - (E) If the distance is less than 350' extend the 8" channel line to the theoretical gore, otherwise use 195'.
 - (F) Use 195' for estimating purposes.
 - (G) Not required for gravel surface crossroad approaches.
 - (H) 4' minimum, 15' maximum from nearest edge of intersection traveled way.
 - (I) Extend dotted line until it touches the edgeline.

BASIS OF ESTIMATE		
LOCATION	ITEM	
Right or Left Side Exit Ramp TAPERED	8" White channel line	580 LF
	24" White stop line	60 LF
	4" White dotted line	148 LF
	4" White edge line	1115 LF
	4" Yellow edge line	1075 LF
Entrance Ramp TAPERED	8" White channel line	390 LF
	4" White dotted line	258 LF
	4" White edge line	1270 LF
	4" Yellow edge line	1075 LF
Right or Left Side Exit Ramp PARALLEL	8" White channel line	396 LF
	24" White stop line	60 LF
	4" White dotted line (C)	258 LF
	4" White edge line	1115 LF
	4" Yellow edge line	1075 LF
Entrance Ramp PARALLEL	8" White channel line	388 LF
	4" White dotted line	283 LF
	4" White edge line	1275 LF
	4" Yellow edge line	1075 LF
Main Line (Both Roadways)	4" White line, 10' line, 30' skip	2640 LF/M
	4" White edge line	10,560 LF/M
	4" Yellow edge line	10,560 LF/M
Cross Road	4" White edge line	2000 LF
	4" Dbl yellow barrier line (4" between)	2000 LF

NORTH DAKOTA DEPARTMENT OF TRANSPORTATION	
8-3-11	
REVISIONS	
DATE	CHANGE
10-17-17	Updated to active voice
10-25-19	Replaced 2" Max dim with Note (I)
11-05-21	Revised labels

This document was originally issued and sealed by
Kirk J Hoff,
Registration Number
PE-4683,
on 11/05/21 and the original document is stored at the
North Dakota Department
of Transportation

NOTES:
1. Continue edge lines through private drives and field drives. Break edge lines for intersections.

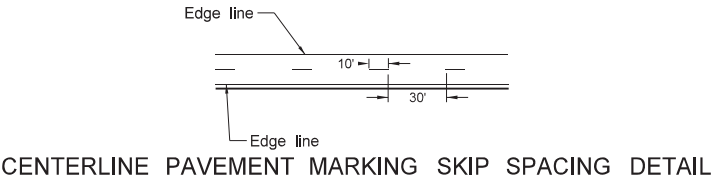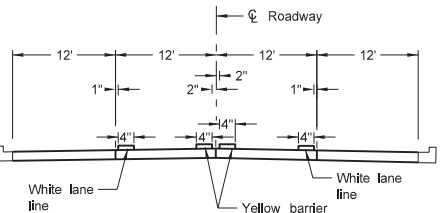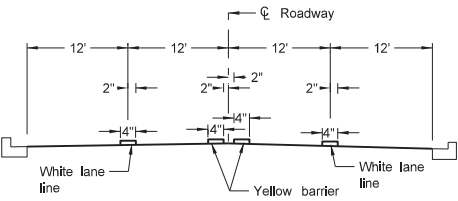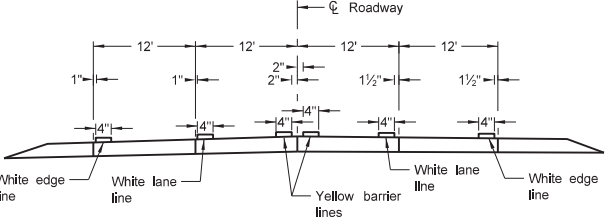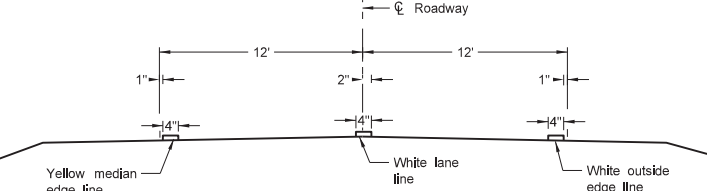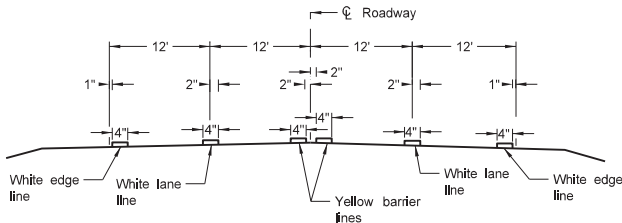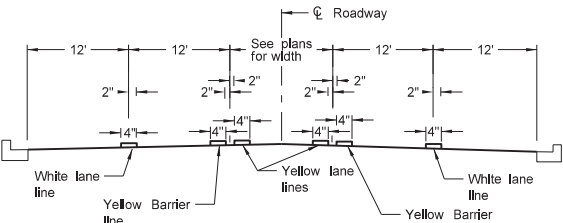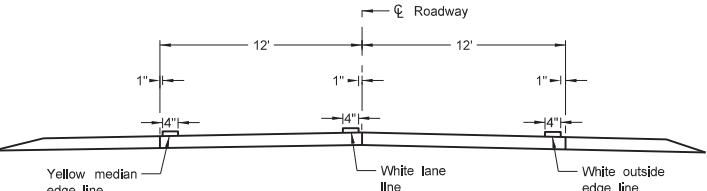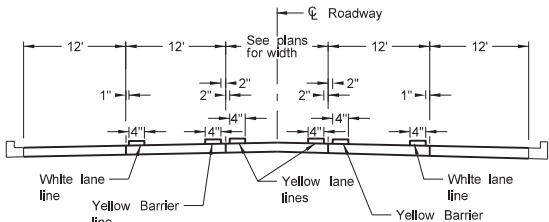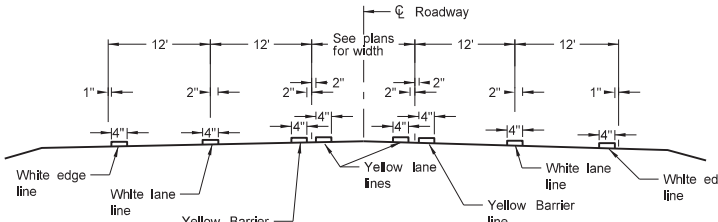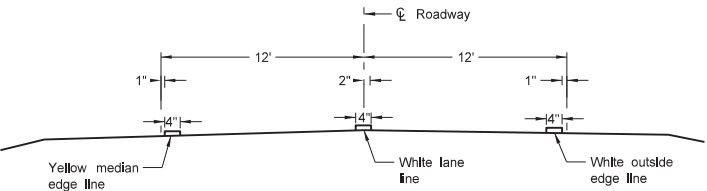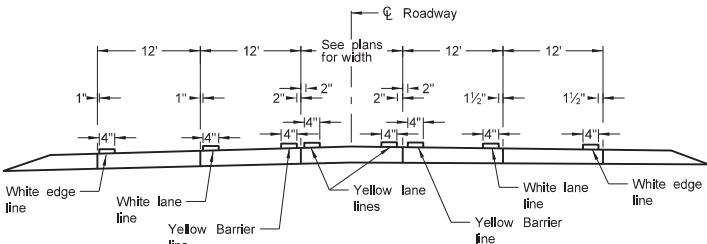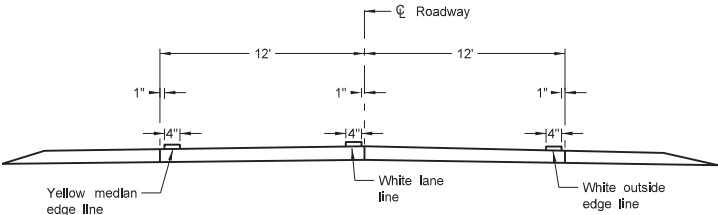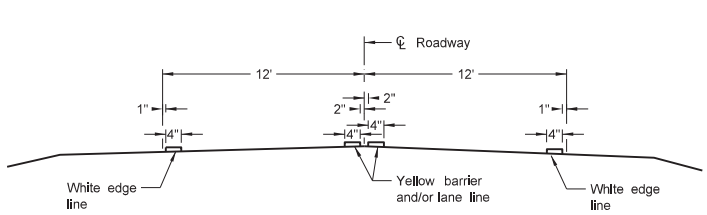


NORTH DAKOTA DEPARTMENT OF TRANSPORTATION	
12-1-10	
REVISIONS	
DATE	CHANGE
10-17-17 08-27-19	Updated to active voice. New Design Engineer PE Stamp.


This document was originally issued and sealed by
Kirk J Hoff,
Registration Number
PE-4683,
on 8/27/19 and the original document is stored at the
North Dakota Department
of Transportation

SHORT-TERM PAVEMENT MARKING

D-762-11

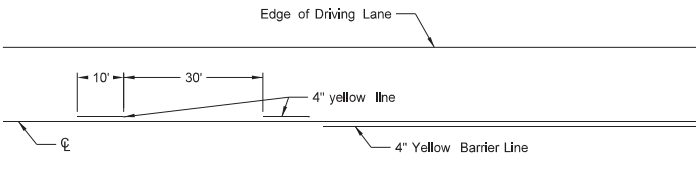


Painted or Tape Lines

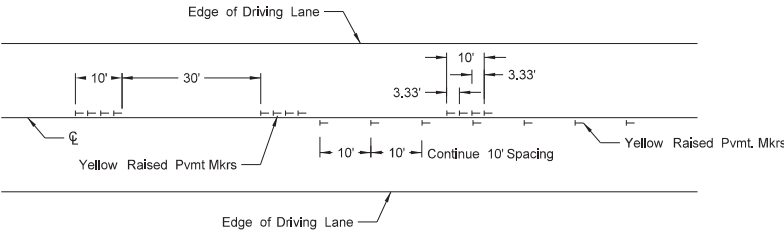


Raised Pavement Markers

TWO-LANE TWO-WAY ROADWAY

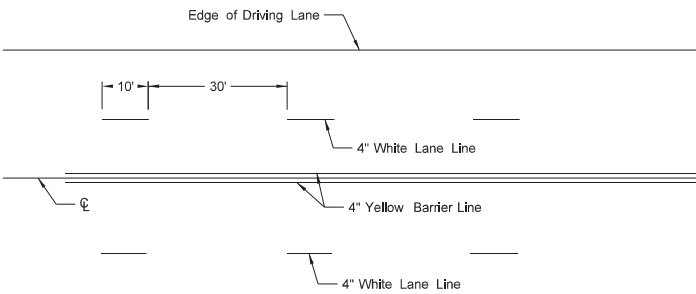


Painted or Tape Lines

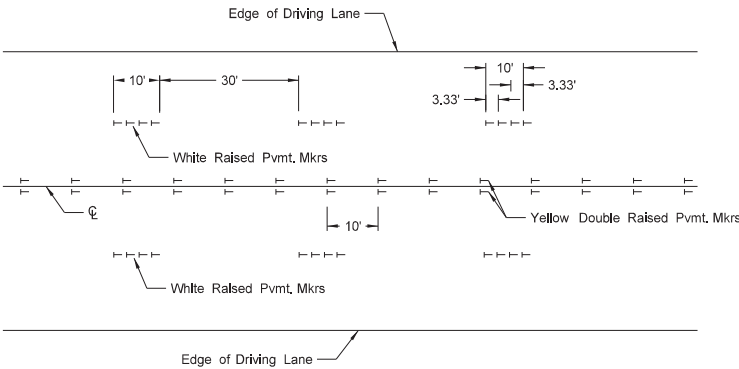


Raised Pavement Markers

FOUR LANE ROADWAY

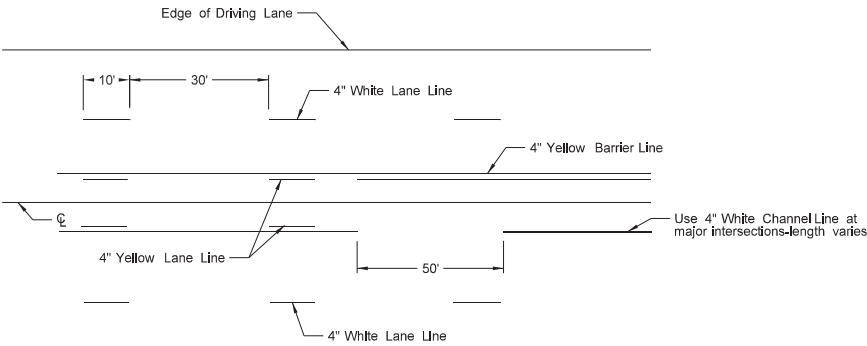


Painted or Tape Lines

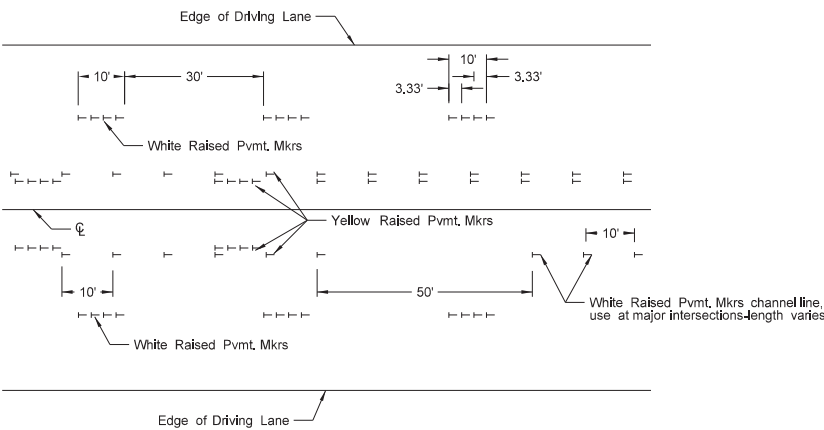


Raised Pavement Markers

FIVE LANE ROADWAY TWO WAY LEFT TURN

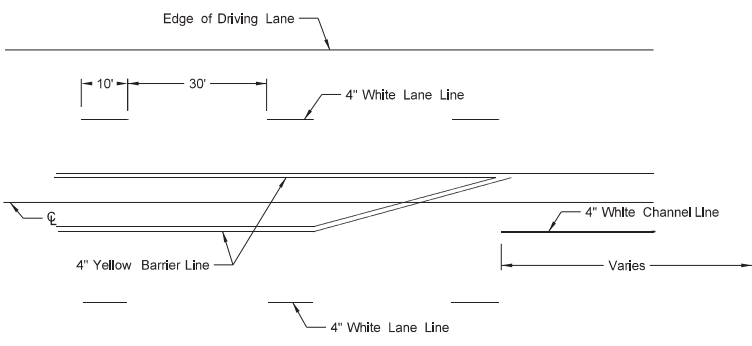

Painted or Tape Lines

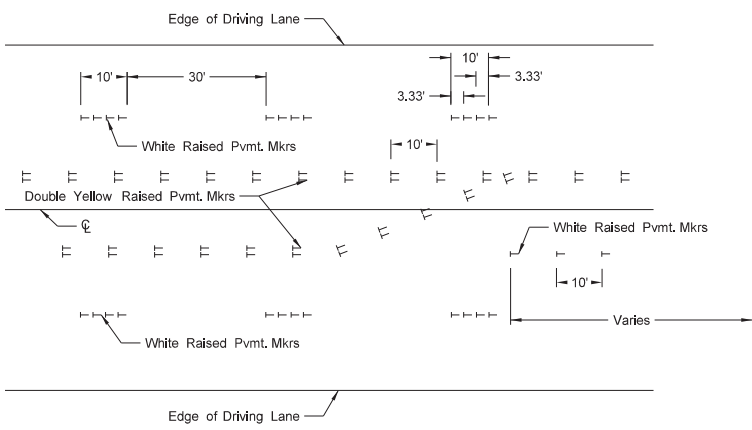

Raised Pavement Markers

FIVE LANE ROADWAY WITH MARKED ISLANDS

- NOTES:
1. Place no passing zones on two-lane two-way roadways as shown. In lieu of short term no passing zone pavement markings, place no passing zone signs. Replace no passing zone signs with short term no passing zone pavement marking within three days.
 2. Place short term center line stripe (paint) on top lift to match exact placement of permanent stripe.
 3. Remove raised markers and tape markings after permanent pavement marking is installed.

NORTH DAKOTA DEPARTMENT OF TRANSPORTATION	
12-1-10	
REVISIONS	
DATE	CHANGE
3-29-16	Re-numbered to be D-762-11 (previously was D-762-6)
10-17-17	Updated to active voice.
8-27-19	New Design Engineer PE Stamp.

This document was originally issued and sealed by

Kirk J Hoff,
Registration Number
PE- 4683,
on 8/27/19 and the original document is stored at the North Dakota Department of Transportation